



Replace existing light fixtures with new LED fixtures in accordance with the fixture schedule on page 27

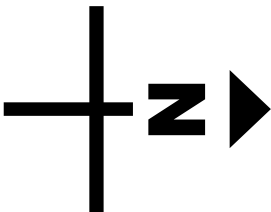


Site:	Horse barn	Drawing:	FP-HB001	Project:	FP LED lighting	Drawn:	JWF	Notes:	Jefferson County Fair Park 503 N Jackson St. Jefferson, WI 53549
Title:	Interior lighting layout	Scale:	NDS	Date:	12/8/2025	Rev:	A		

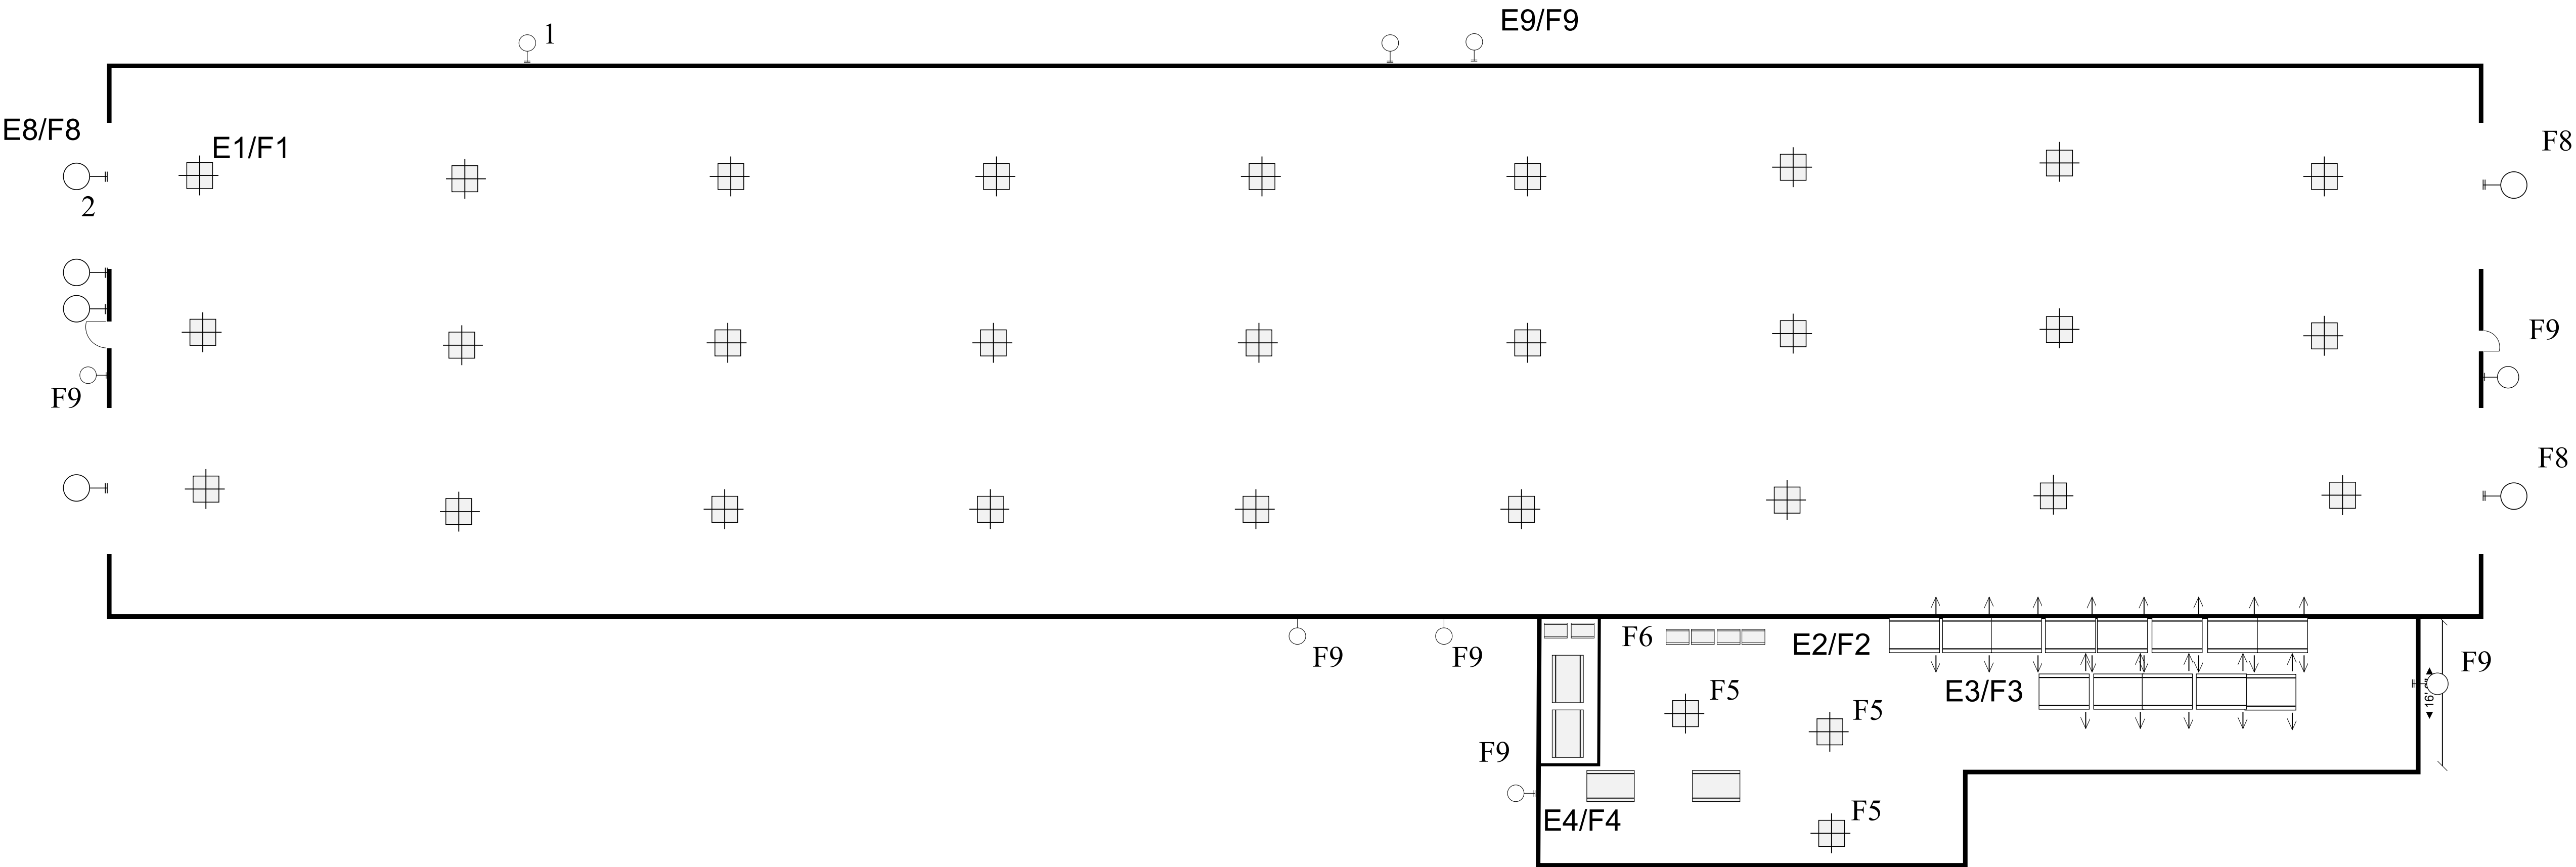


Replace existing light fixtures with new LED fixtures in accordance with the fixture schedule on page 27


- 1 - Existing to remain
- 2 - Master photo sensor for all exterior lights

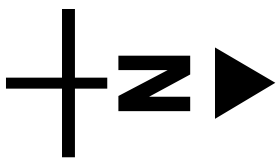


c	Dairy barn	Drawing: FP-DB002	Project: FP LED lighting	Drawn: JWF	Notes:	Jefferson County Fair Park 503 N Jackson St. Jefferson, WI 53549
Title:	Interior lighting layout	Scale: NDS	Date: 12/8/2025	Rev: A		

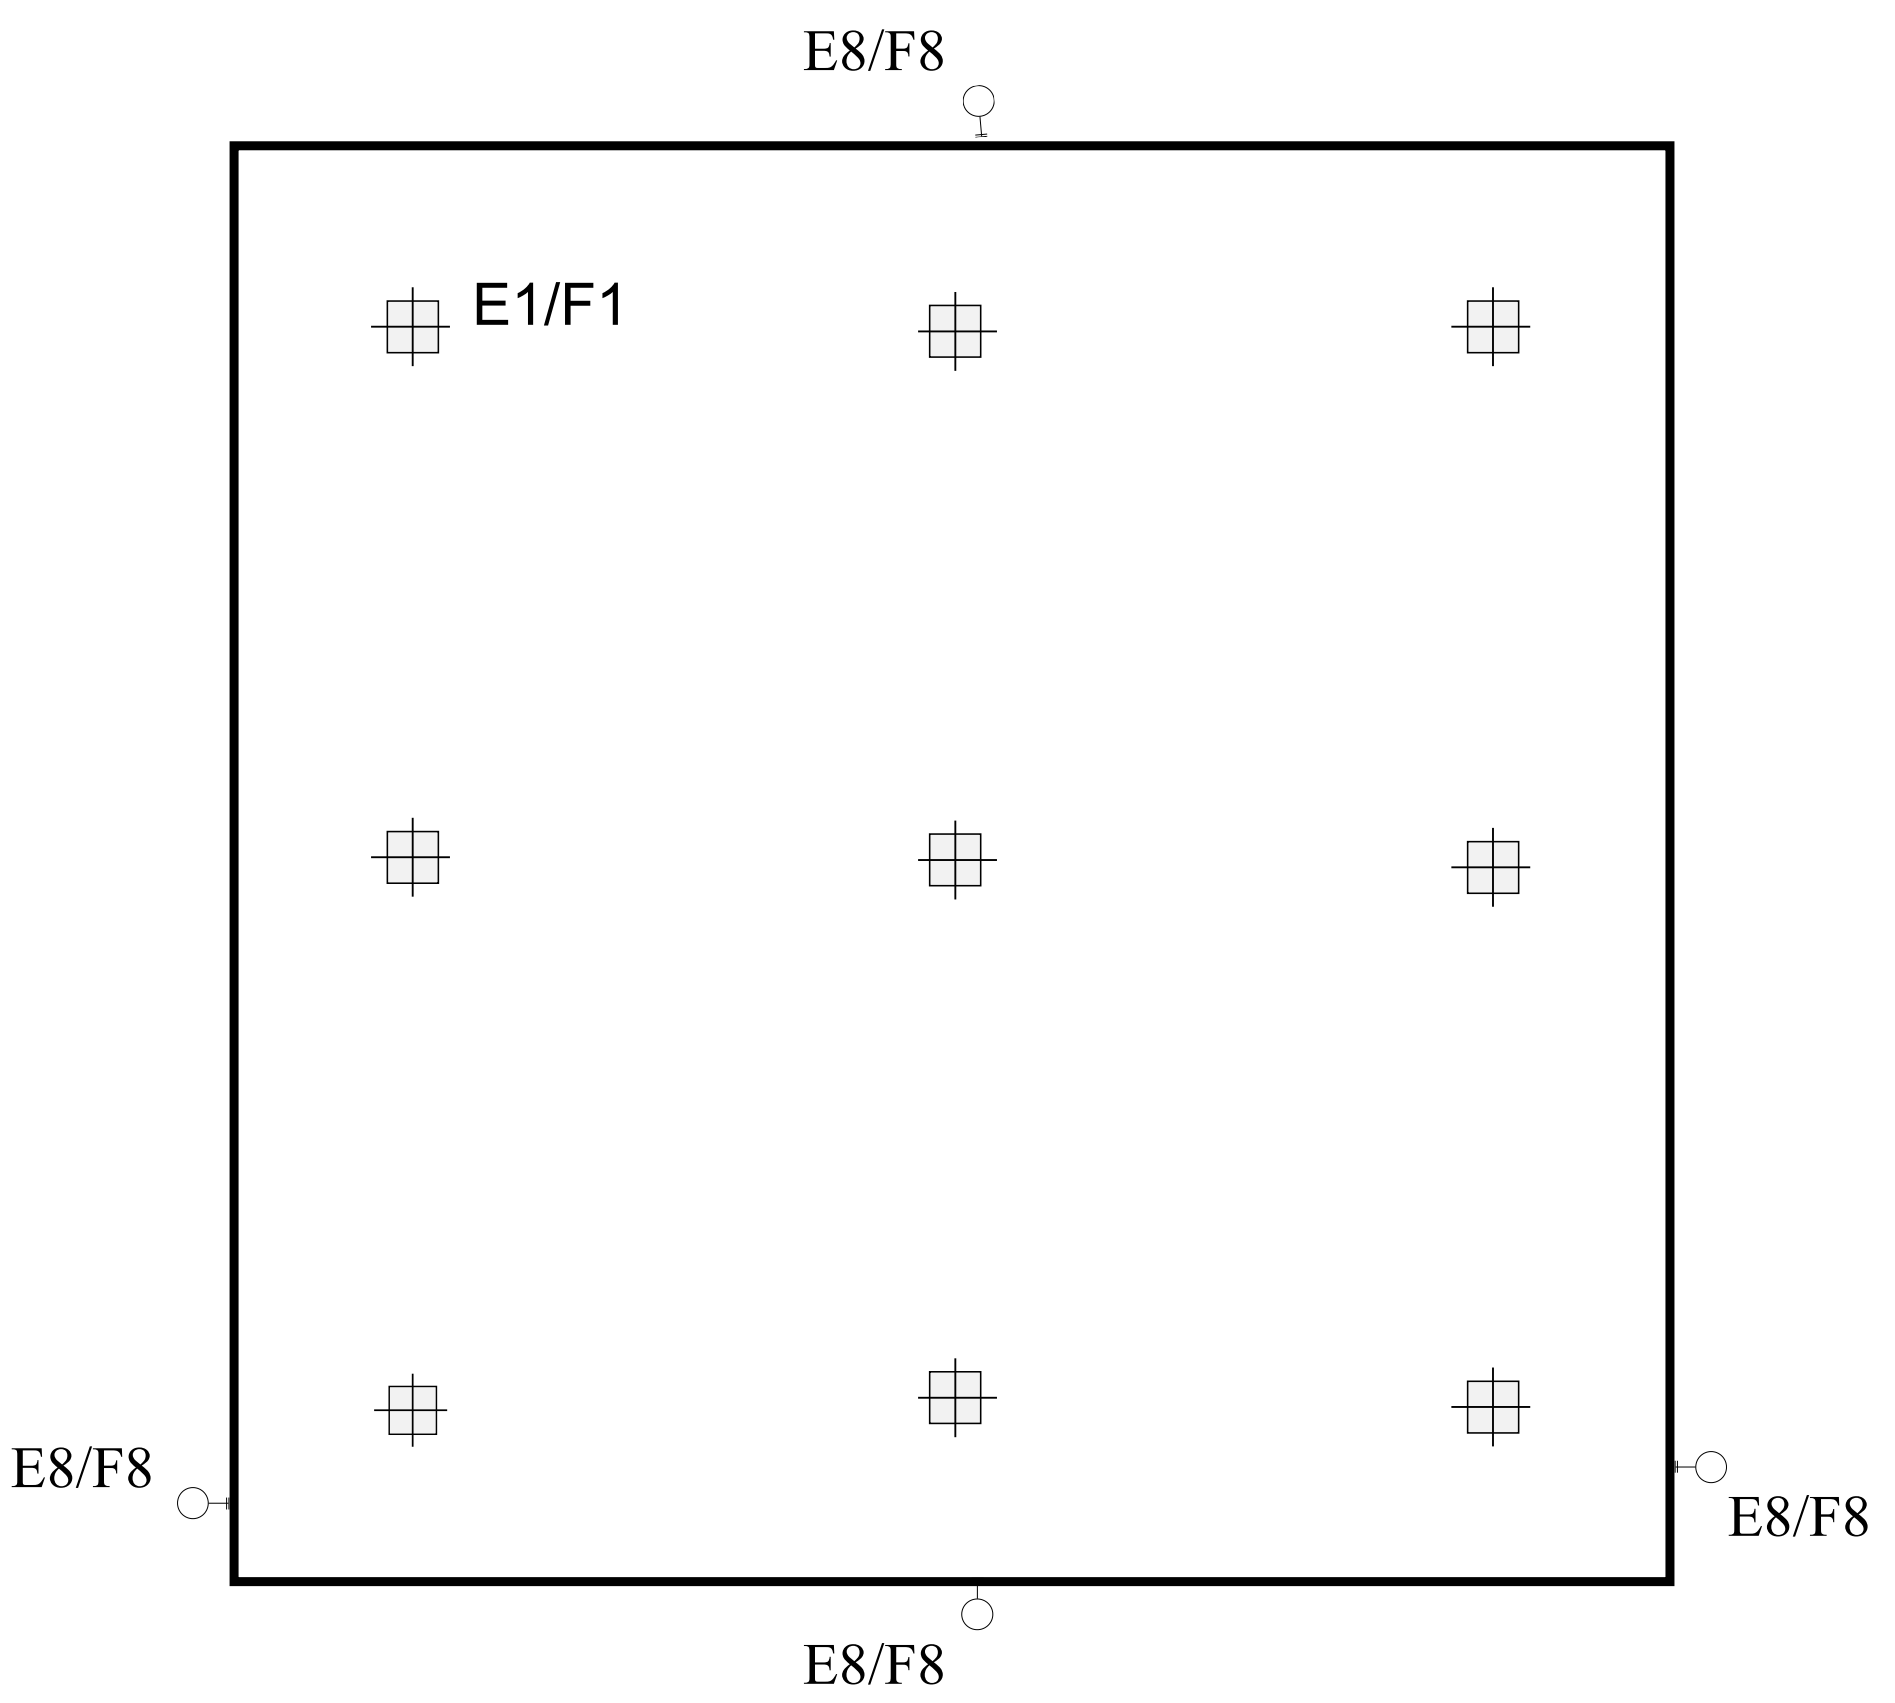


Replace existing light fixtures with new LED fixtures in accordance with the fixture schedule on page 27

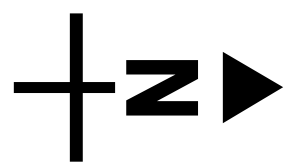

Site:	Indoor warm-up arena	Drawing: FP-WA001	Project: FP LED lighting	Drawn: JWF	Notes:	Jefferson County Fair Park 503 N Jackson St. Jefferson, WI 53549
Title:	Interior lighting layout	Scale: NDS	Date: 12/8/2025	Rev: A		

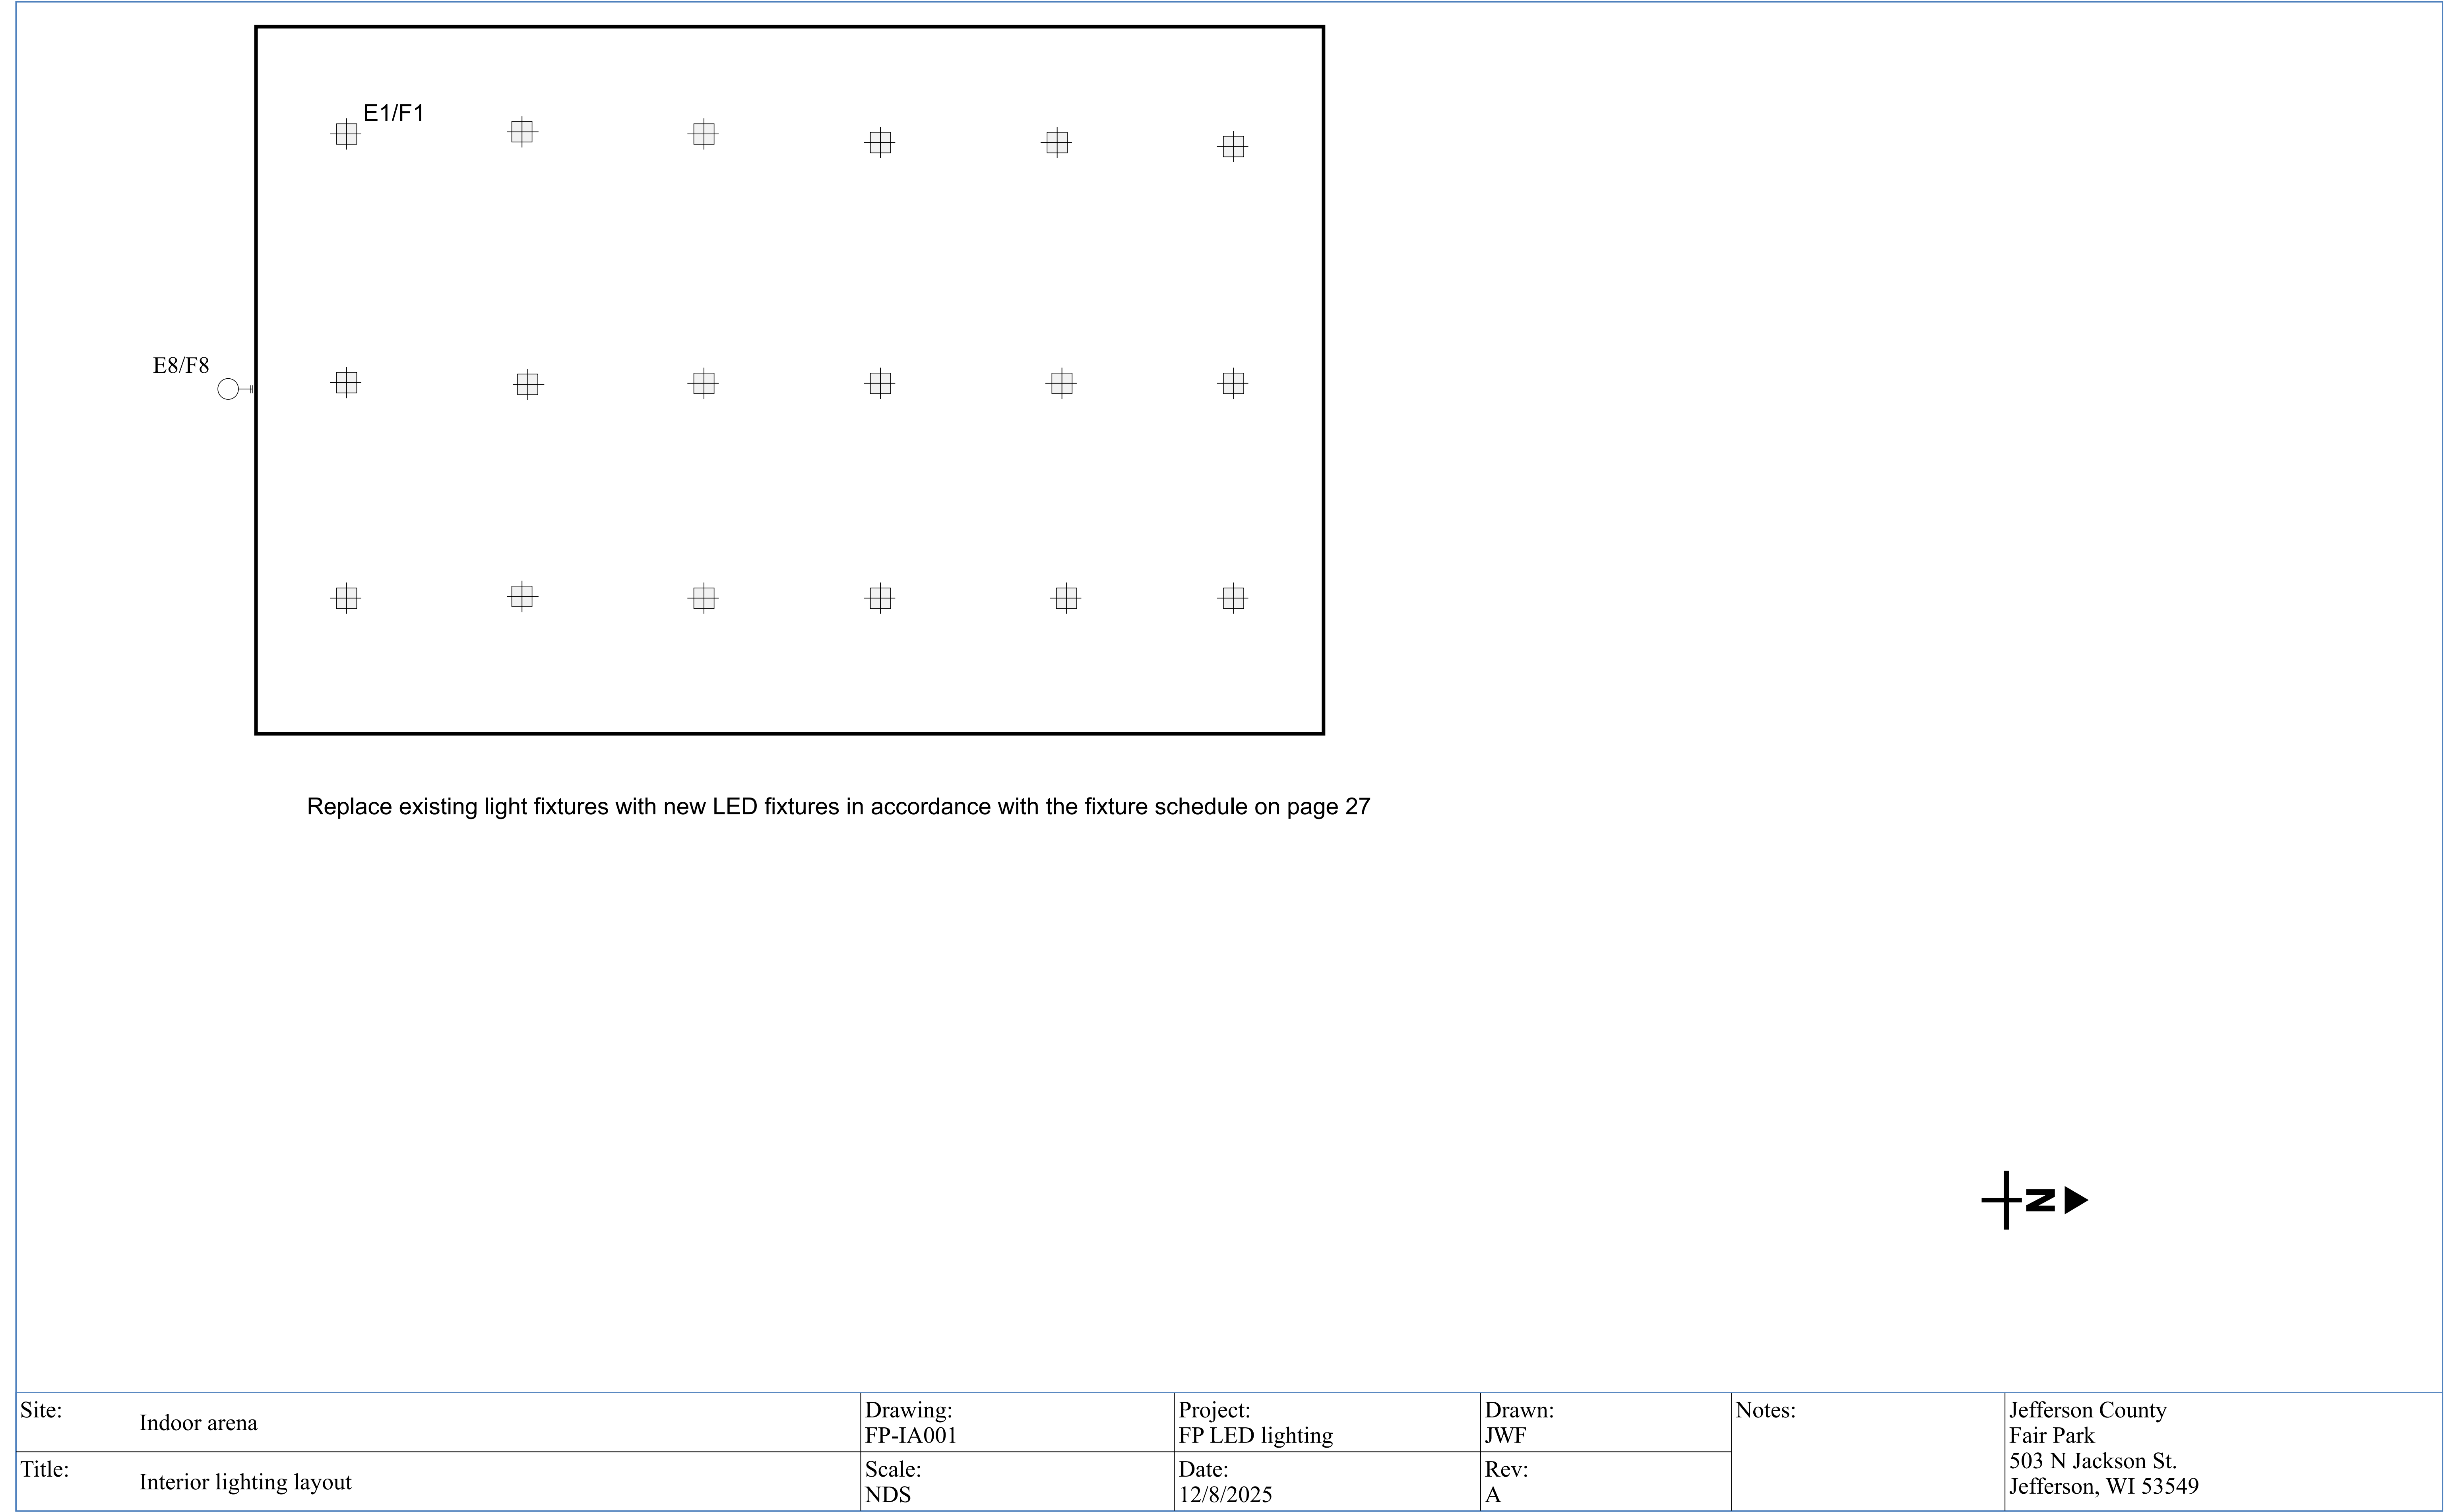


Site:	Indoor arena	Drawing: FP-IA001	Project: FP LED lighting	Drawn: JWF	Notes:	Jefferson County Fair Park 503 N Jackson St. Jefferson, WI 53549
Title:	Interior lighting layout	Scale: NDS	Date: 12/8/2025	Rev: A		

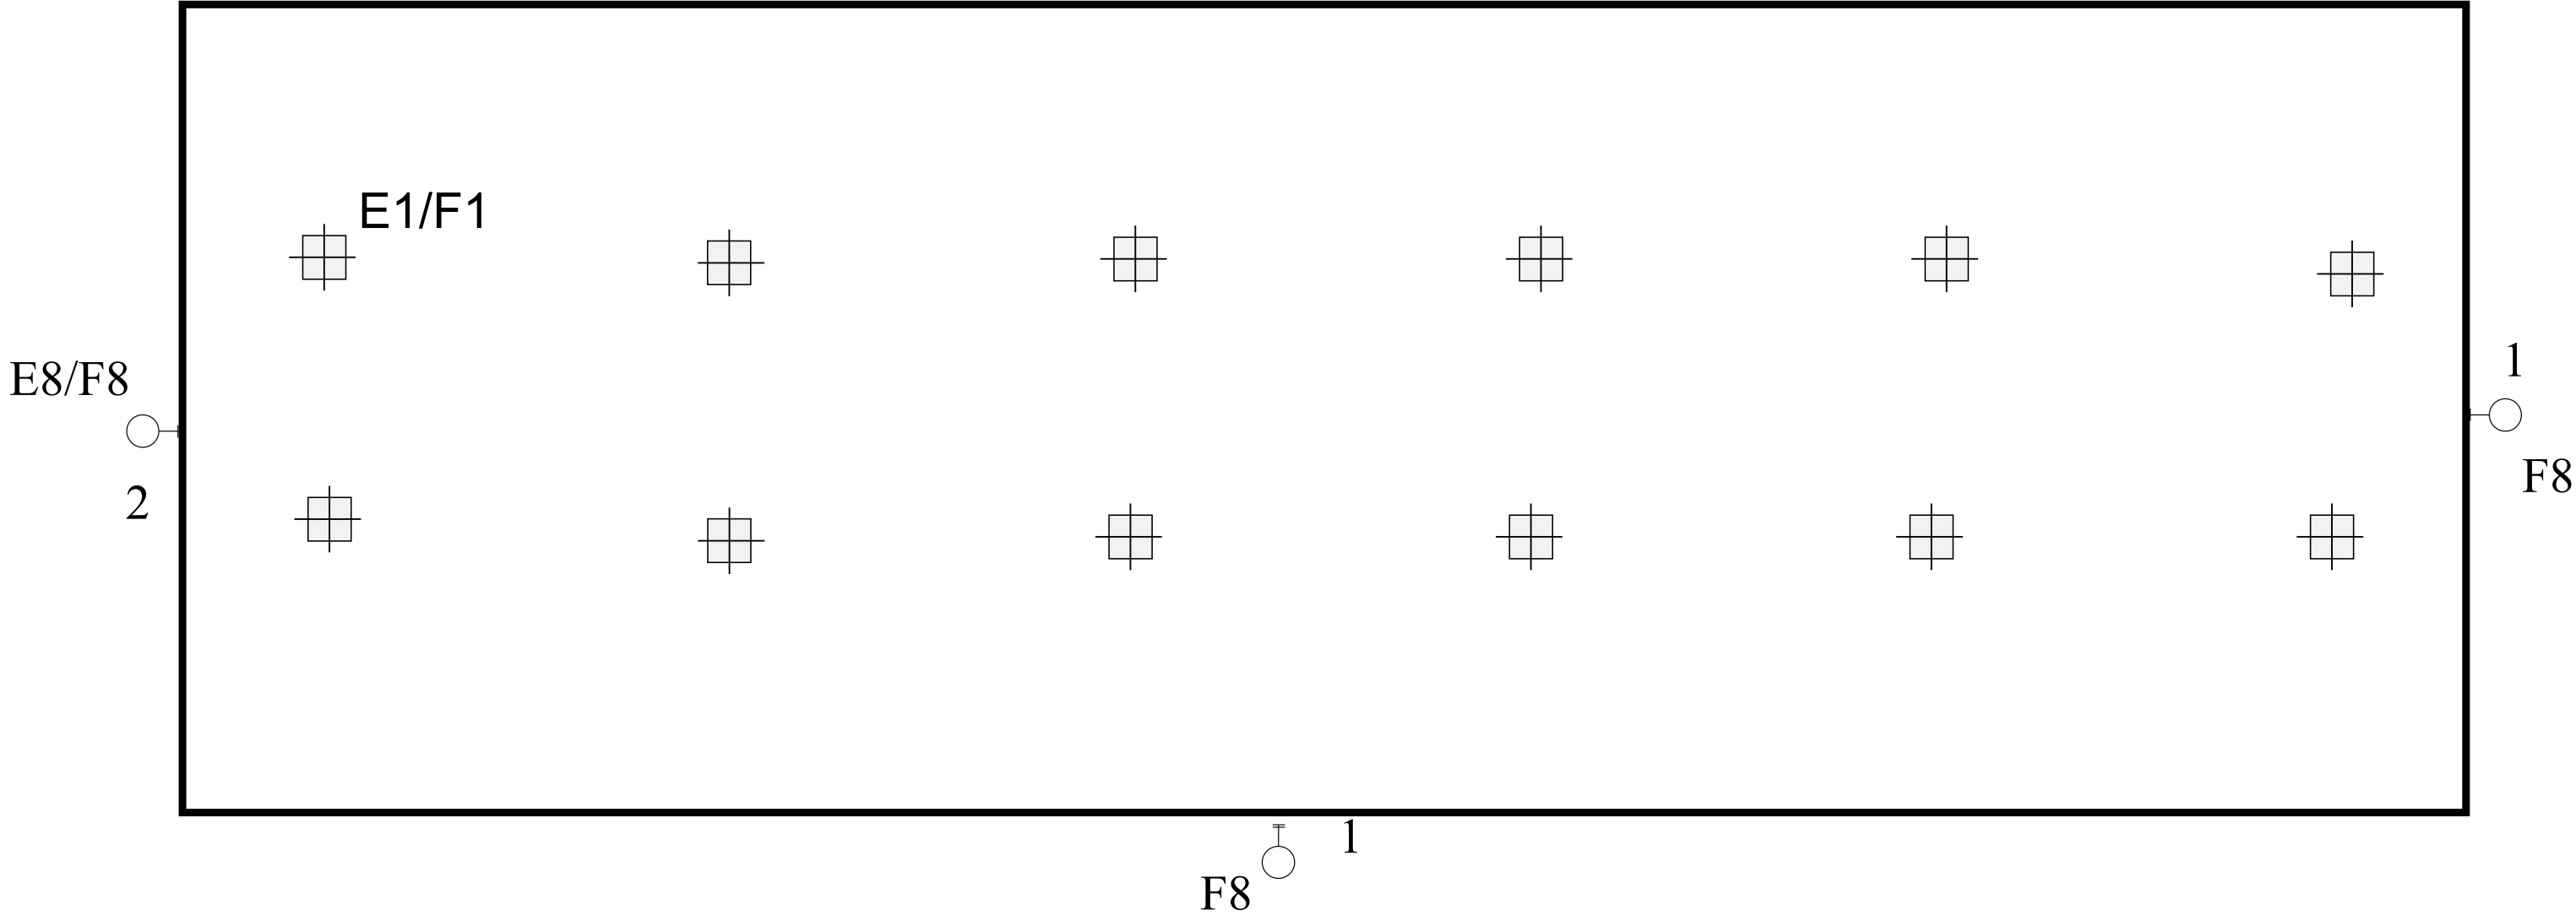


Replace existing light fixtures with new LED fixtures in accordance with the fixture schedule on page 27

- 1 - These fixtures are incremental / new to the building, placement on the building to be field verified by Owners onsite staff and wire way shall be field verified from the nearest junction box or existing wireway
- 2 - Master photo sensor for all exterior lights

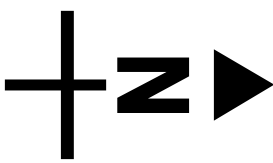


Site:	Draft horse barn	Drawing: FP-DH001	Project: FP LED lighting	Drawn: JWF	Notes:	Jefferson County Fair Park 503 N Jackson St. Jefferson, WI 53549
Title:	Interior lighting layout	Scale: NDS	Date: 12/8/2025	Rev: A		

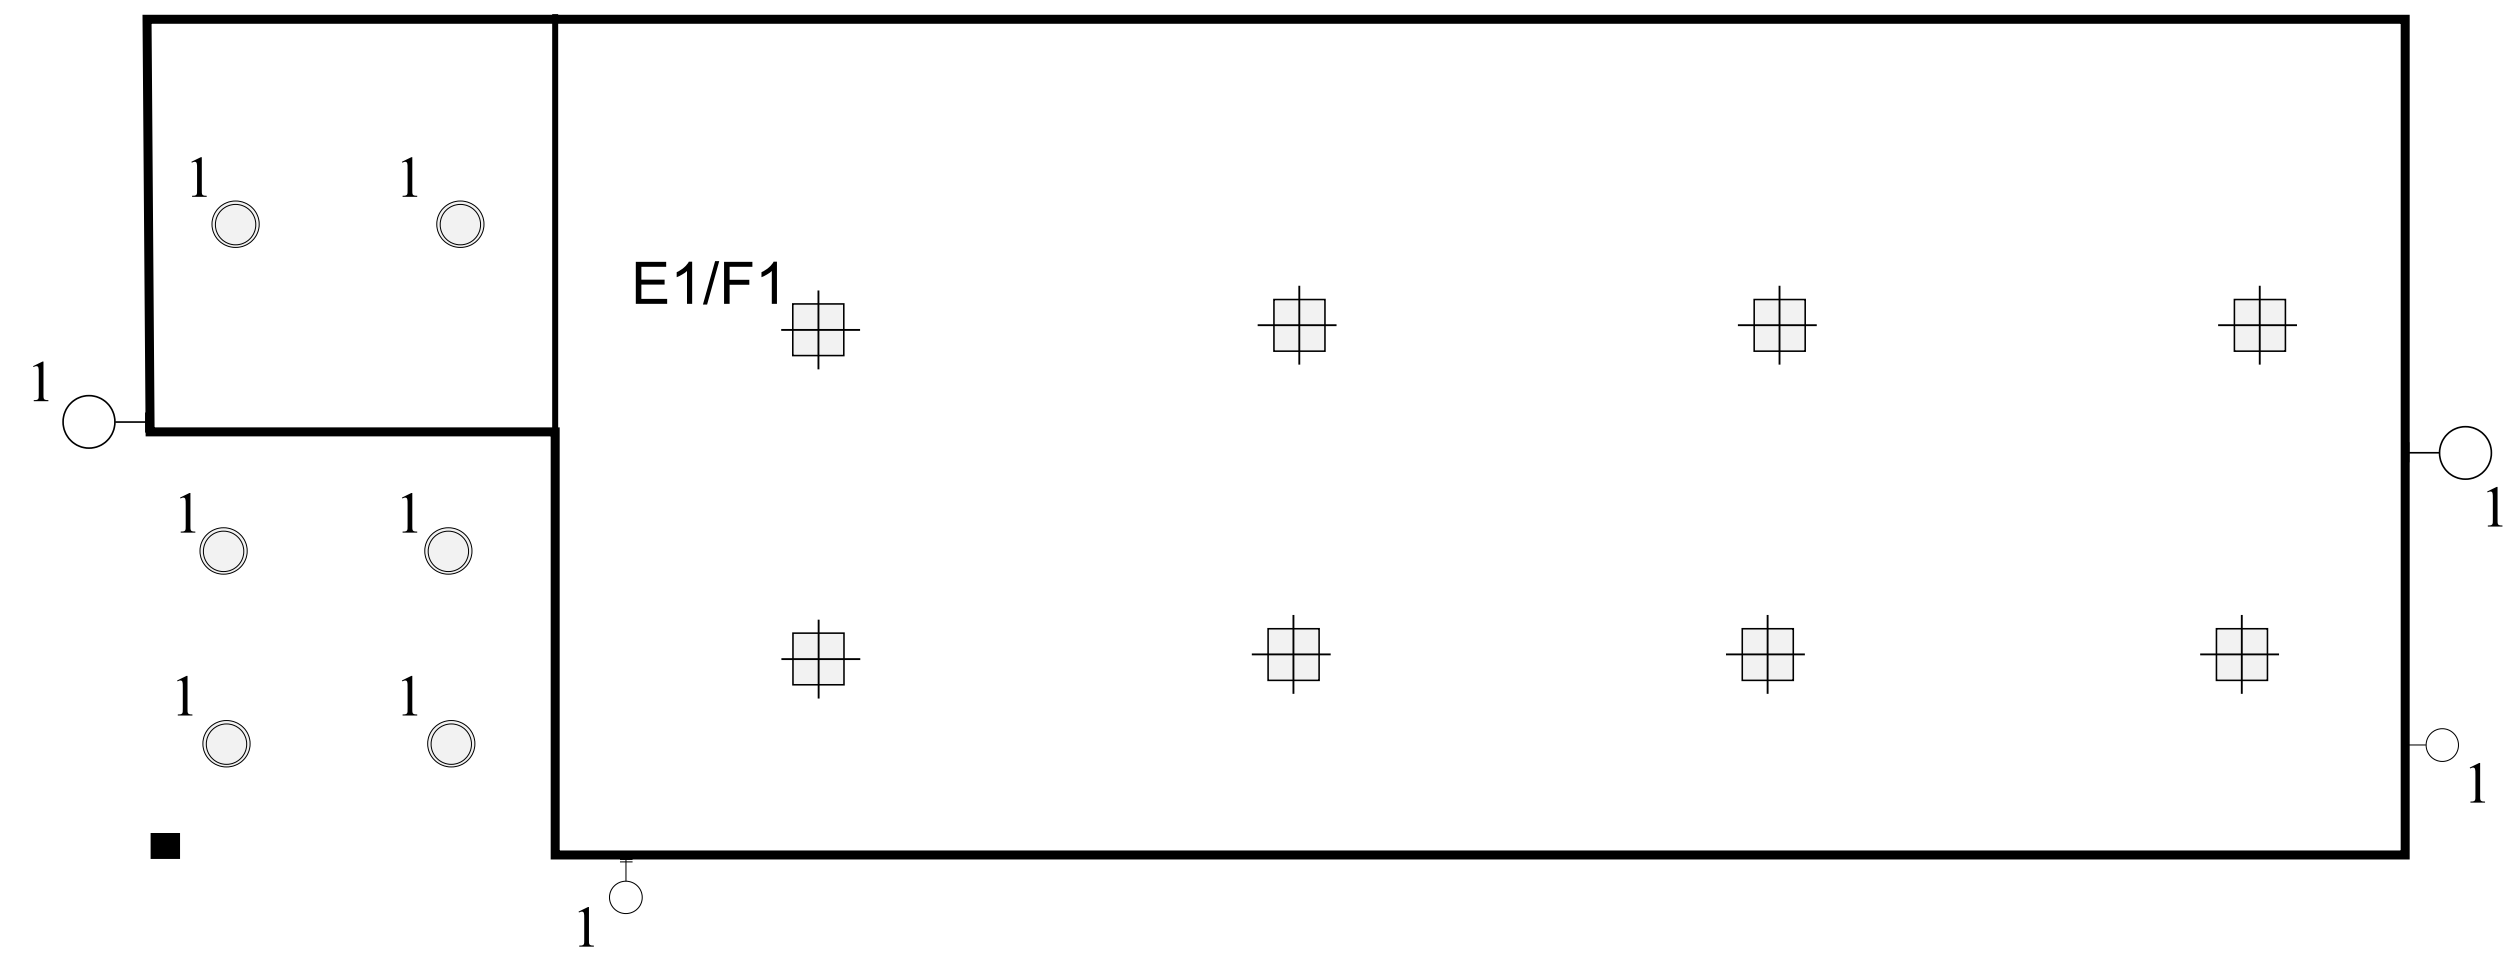


Replace existing light fixtures with new LED fixtures in accordance with the fixture schedule on page 27

1 - Existing fixture to remain

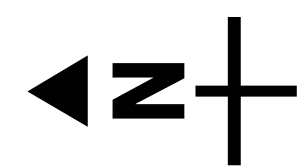


Site:	New swine barn	Drawing: FP-NSB001	Project: FP LED lighting	Drawn: JWF	Notes:	Jefferson County Fair Park 503 N Jackson St. Jefferson, WI 53549
Title:	Interior lighting layout	Scale: NDS	Date: 12/8/2025	Rev: A		

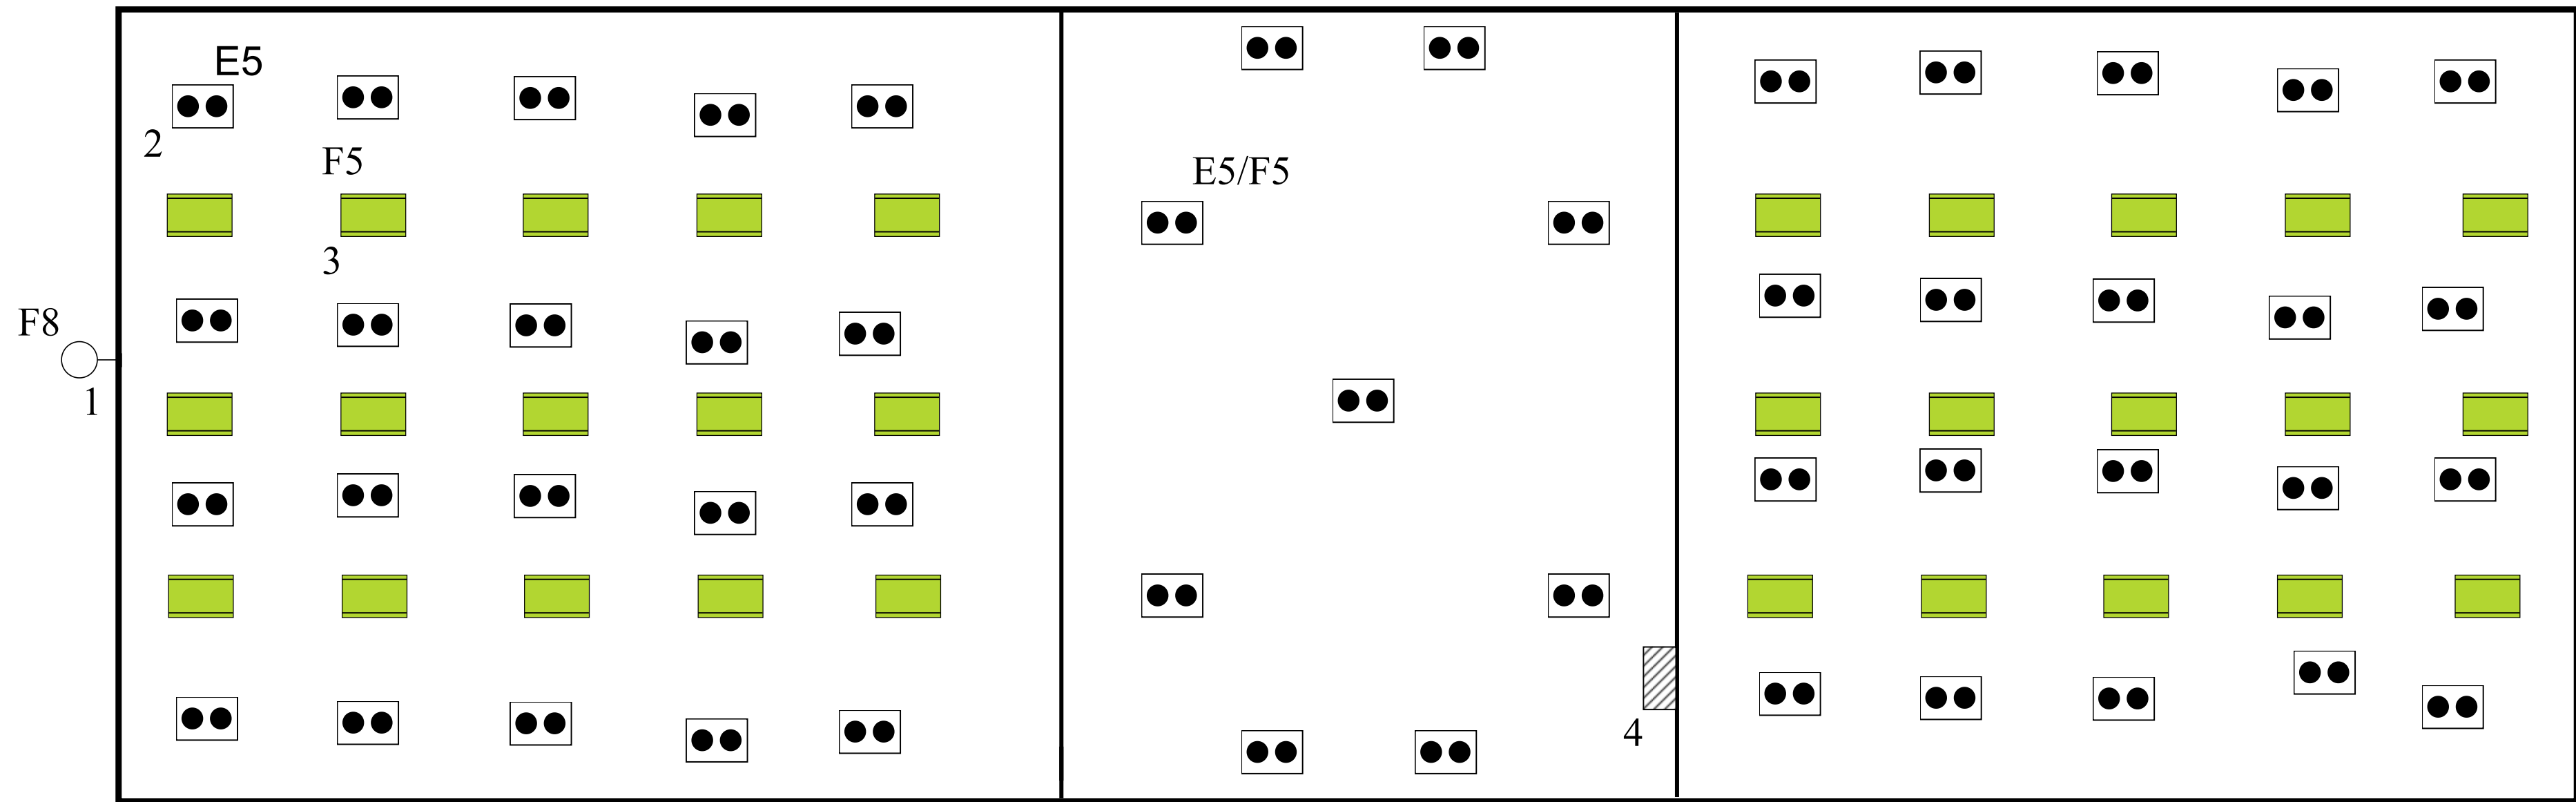


- 1 - Incremental light fixture, field verify placement with site director. Contractor to field verify wire pathway to the nearest existing junction box or wireway.
2 - Removal of existing fixtures, conduit, and wiring
3 - Contractor to coordinate fixture layout and wire pathway with site director
4 - Existing panel to be re-used. North and south wings of structure shall be wired to separate circuits to switch A - center row of pens, switch B - both outside row of pens, and switch C - center bay of the structure
5 - New LED fixtures in accordance with the fixture schedule on page 27


Alternate #01: Legacy Swine Building Modifications
Provide a deduct alternate to only replace fixtures without the reconfiguration power cable and fixture locations shown above.

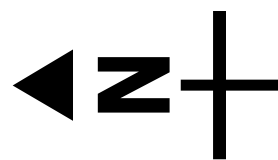


Site:	Legacy swine barn	Drawing: FP-LSB001	Project: FP LED lighting	Drawn: JWF	Notes:	Jefferson County Fair Park 503 N Jackson St. Jefferson, WI 53549
Title:	Interior lighting layout	Scale: NDS	Date: 12/8/2025	Rev: A		

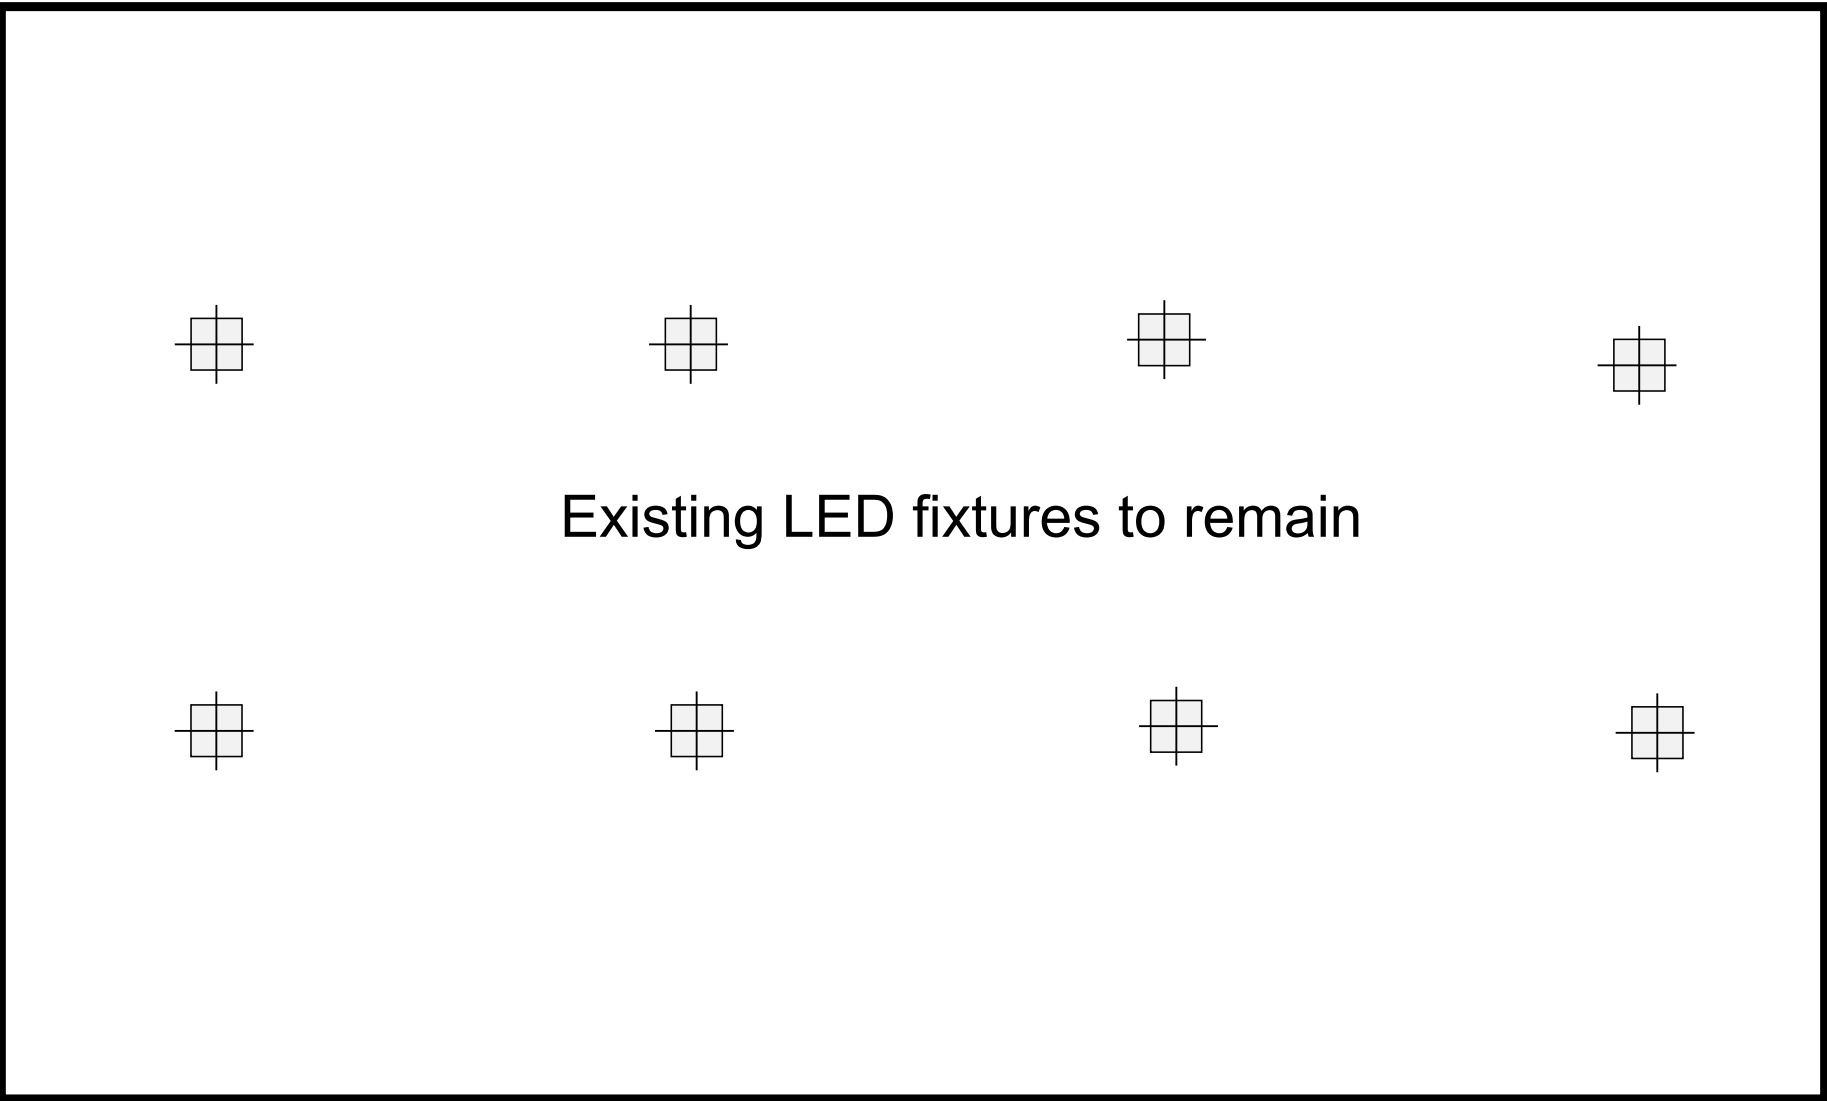

F8 - replaces an existing fixture

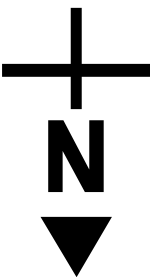


Site: Meat Animal Products(MAP) barn	Drawing: FP-MAP001	Project: FP LED lighting	Drawn: JWF	Notes:	Jefferson County Fair Park 503 N Jackson St. Jefferson, WI 53549
Title: Interior lighting layout	Scale: NDS	Date: 12/8/2025	Rev: A		

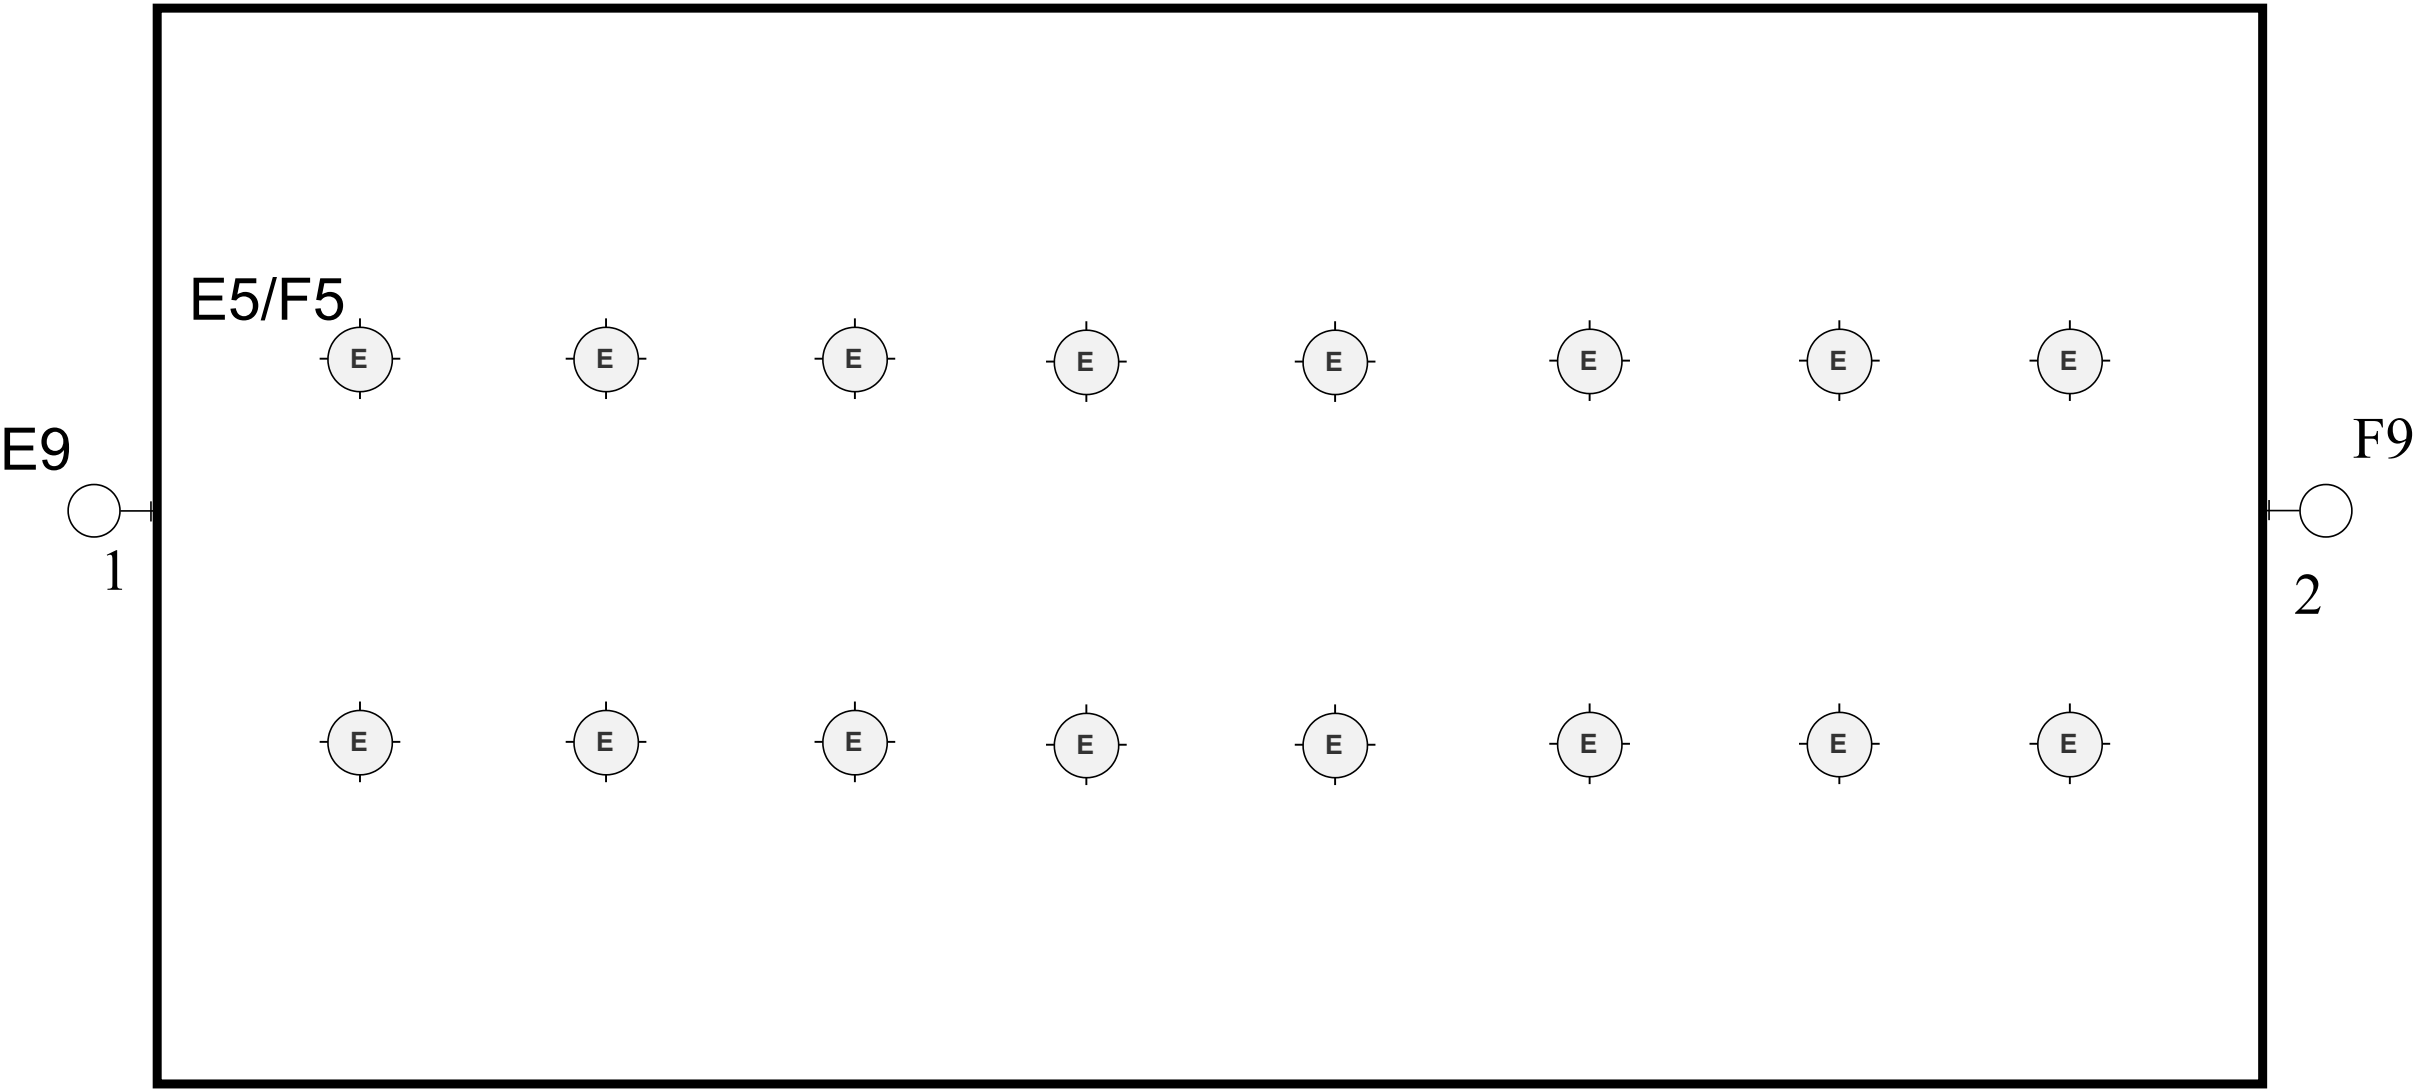


- 1 - Existing to remain
- 2 - Incremental light fixture, location to be field coordinated with Site Director, contractor to field verify wire pathway

Replace existing light fixtures with new LED fixtures in accordance with the fixture schedule on page 27

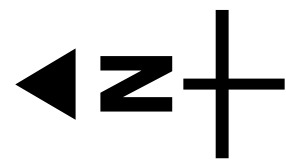


Site: Beef barn	Drawing: FP-BB001	Project: FP LED lighting	Drawn: JWF	Notes:	Jefferson County Fair Park 503 N Jackson St. Jefferson, WI 53549
Title: Interior lighting layout	Scale:NDS	Date: 12/8/2025	Rev: A		

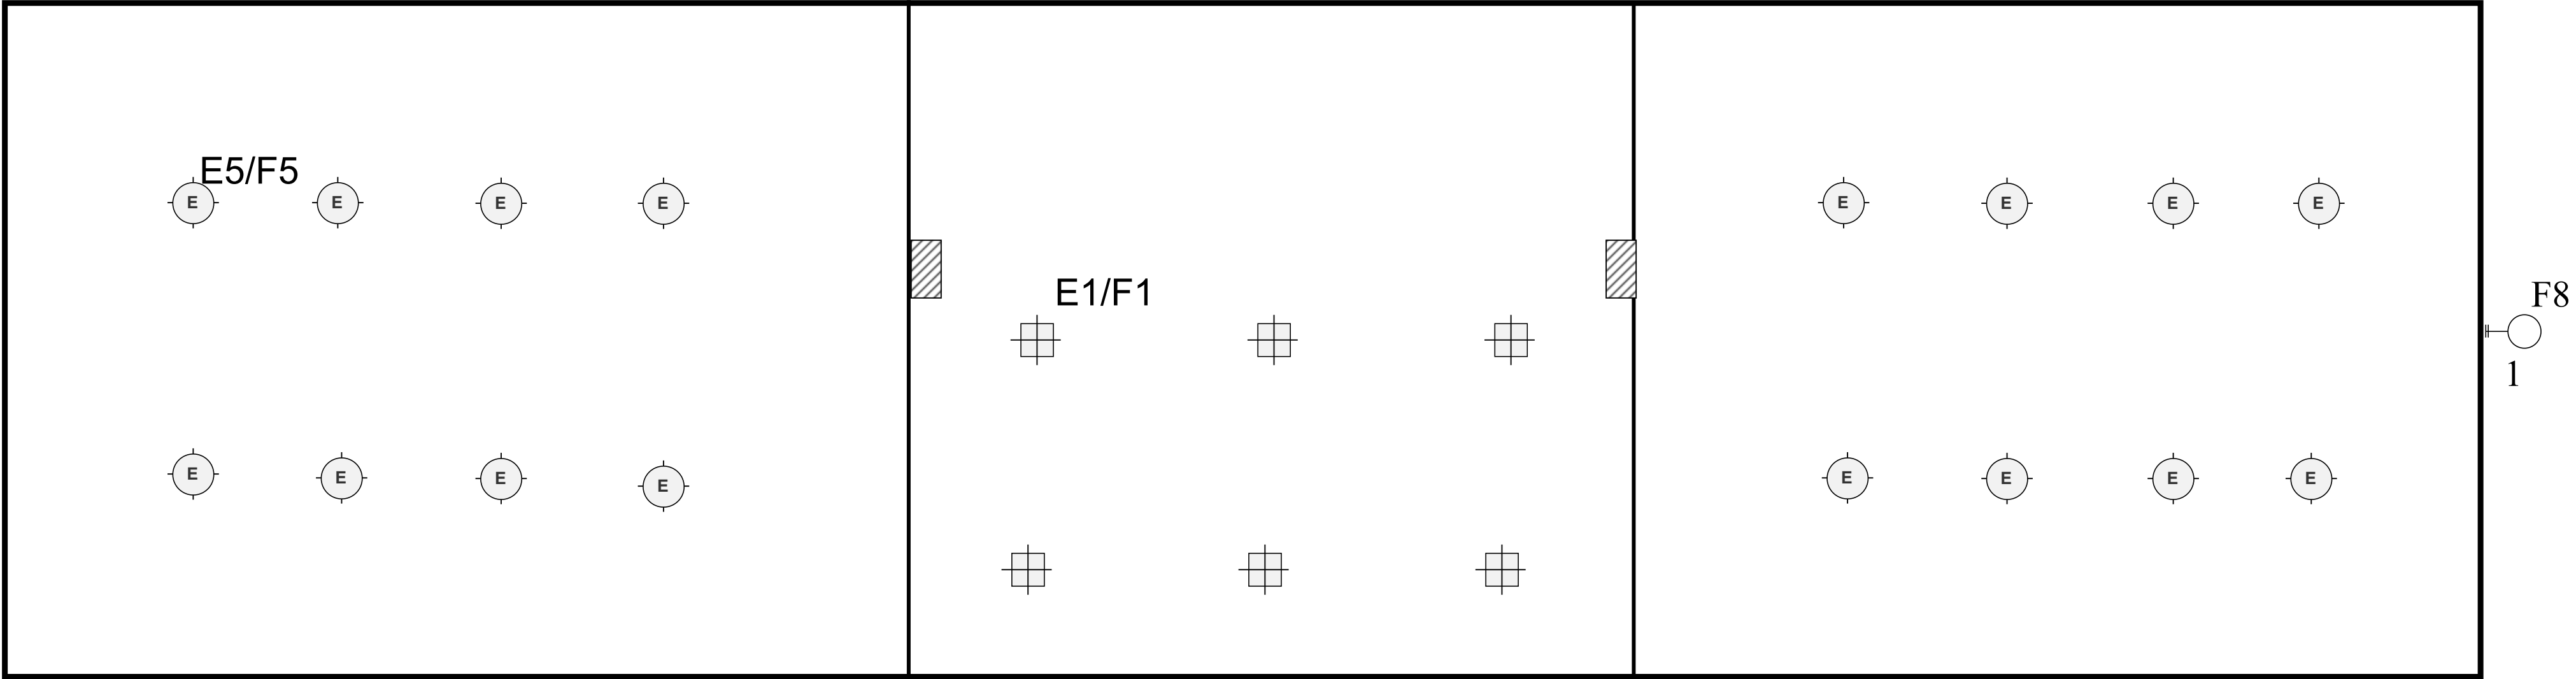


Replace existing light fixtures with new LED fixtures in accordance with the fixture schedule on page 27

1 - Incremental light fixture, location to be field coordinated with Site Director, contractor
to field verify wire pathway

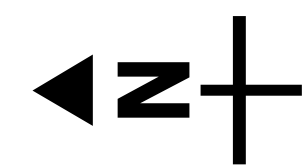


Site:	Sheep barn	Drawing: FP-SB001	Project: FP LED lighting	Drawn: JWF	Notes:	Jefferson County Fair Park 503 N Jackson St. Jefferson, WI 53549
Title:	Interior lighting layout	Scale: NDS	Date: 12/8/2025	Rev: A		

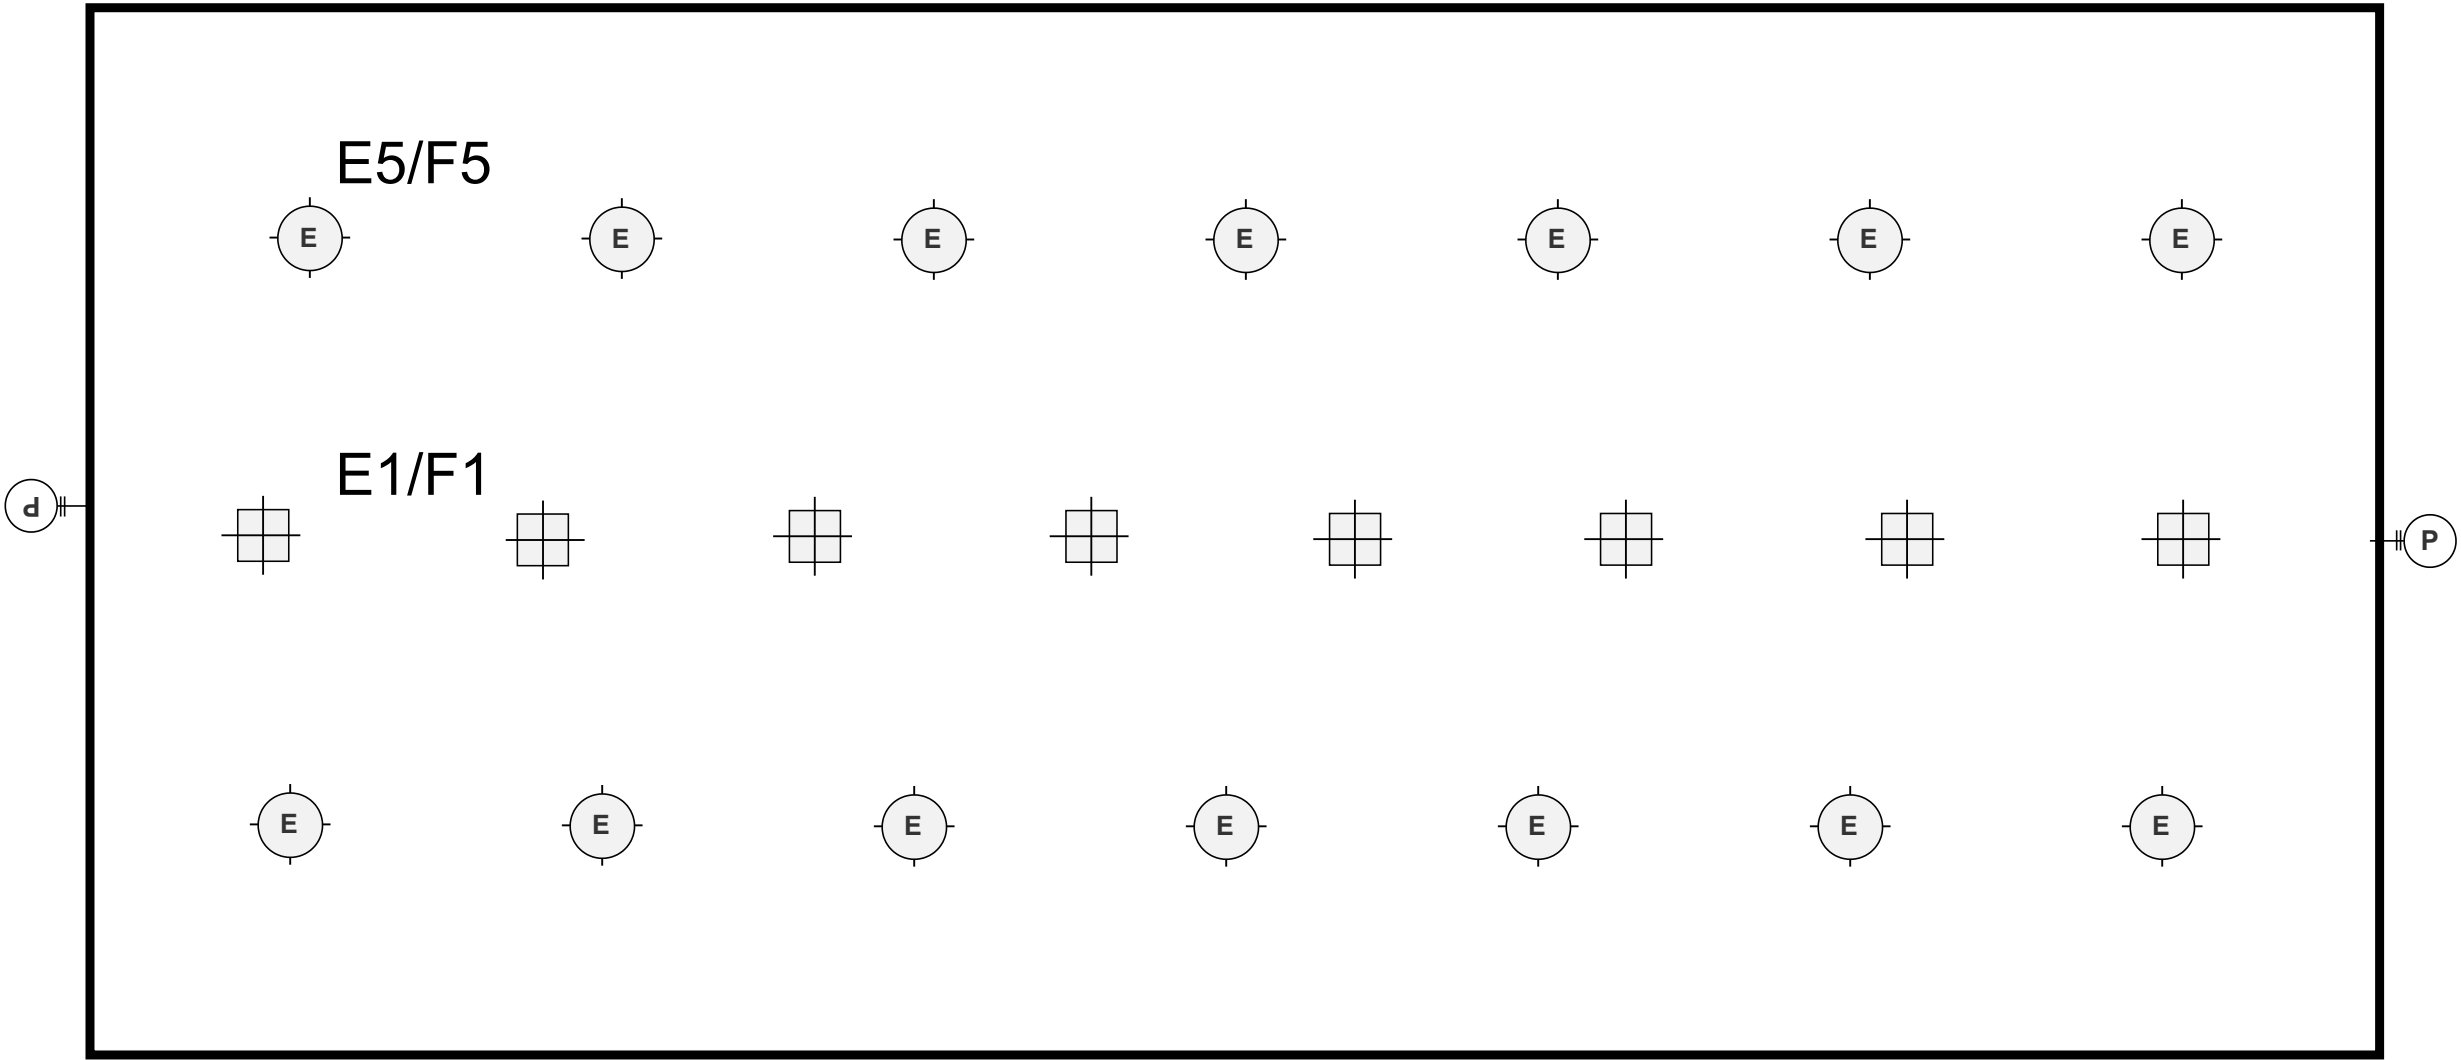



Replace existing light fixtures with new LED fixtures in accordance with the fixture schedule on page 27

 Existing to remain

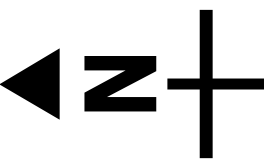


Site:	Goat barn	Drawing: FP-GB001	Project: FP LED lighting	Drawn: JWF	Notes:	Jefferson County Fair Park 503 N Jackson St. Jefferson, WI 53549
Title:	Interior lighting layout	Scale:NDS	Date: 12/8/2025	Rev: A		

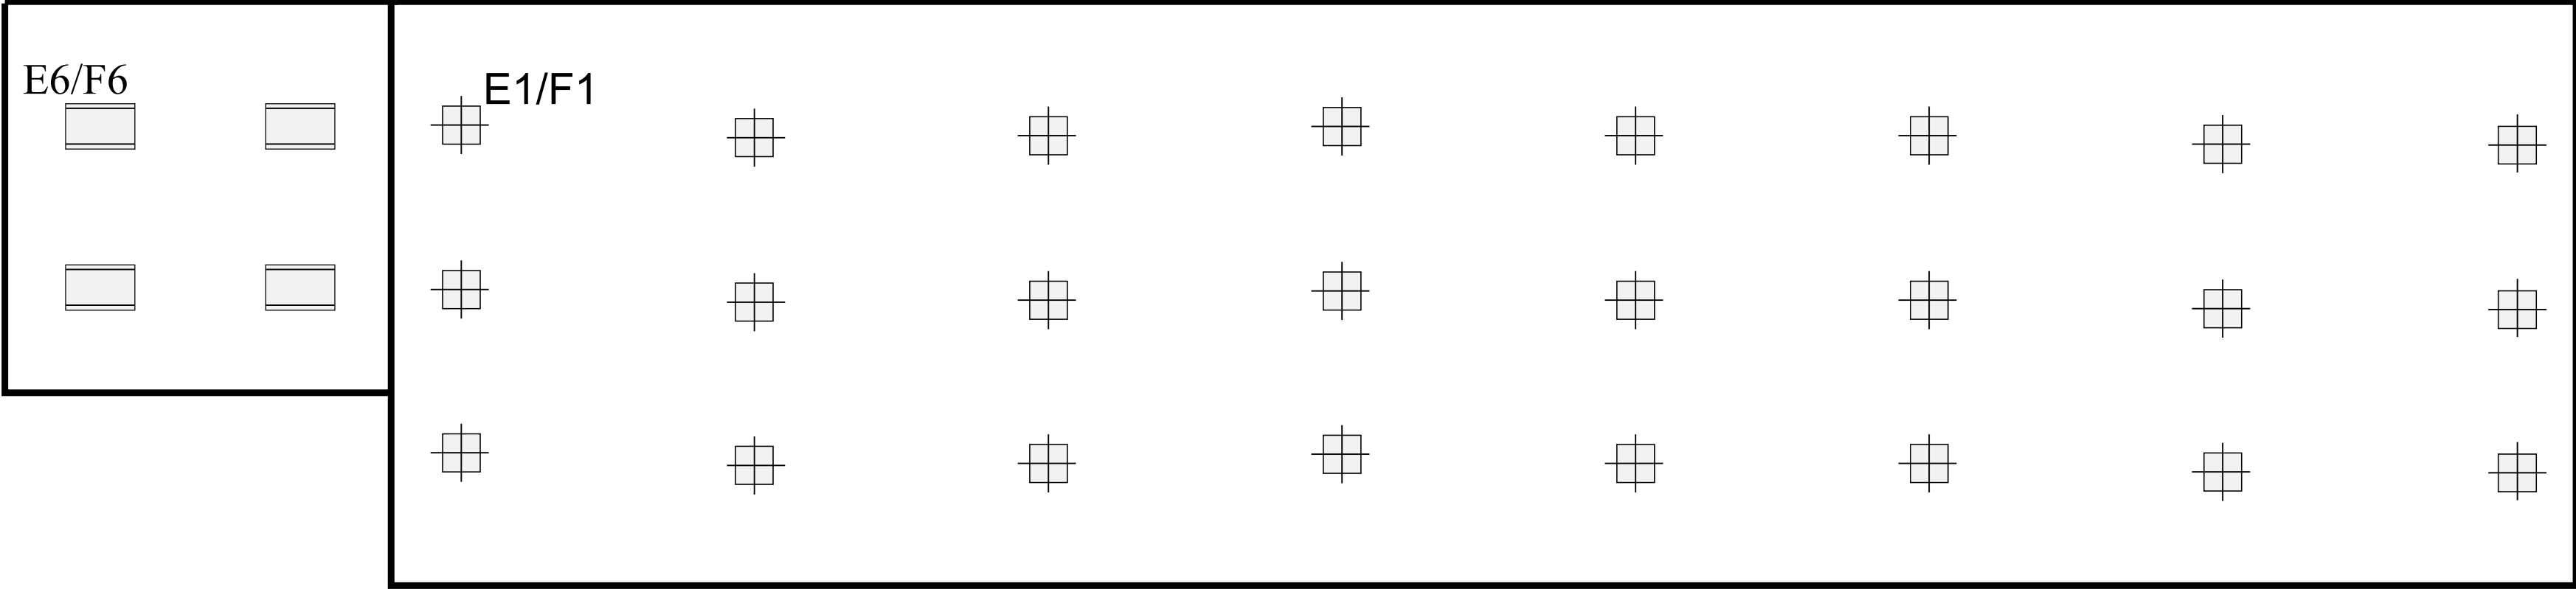


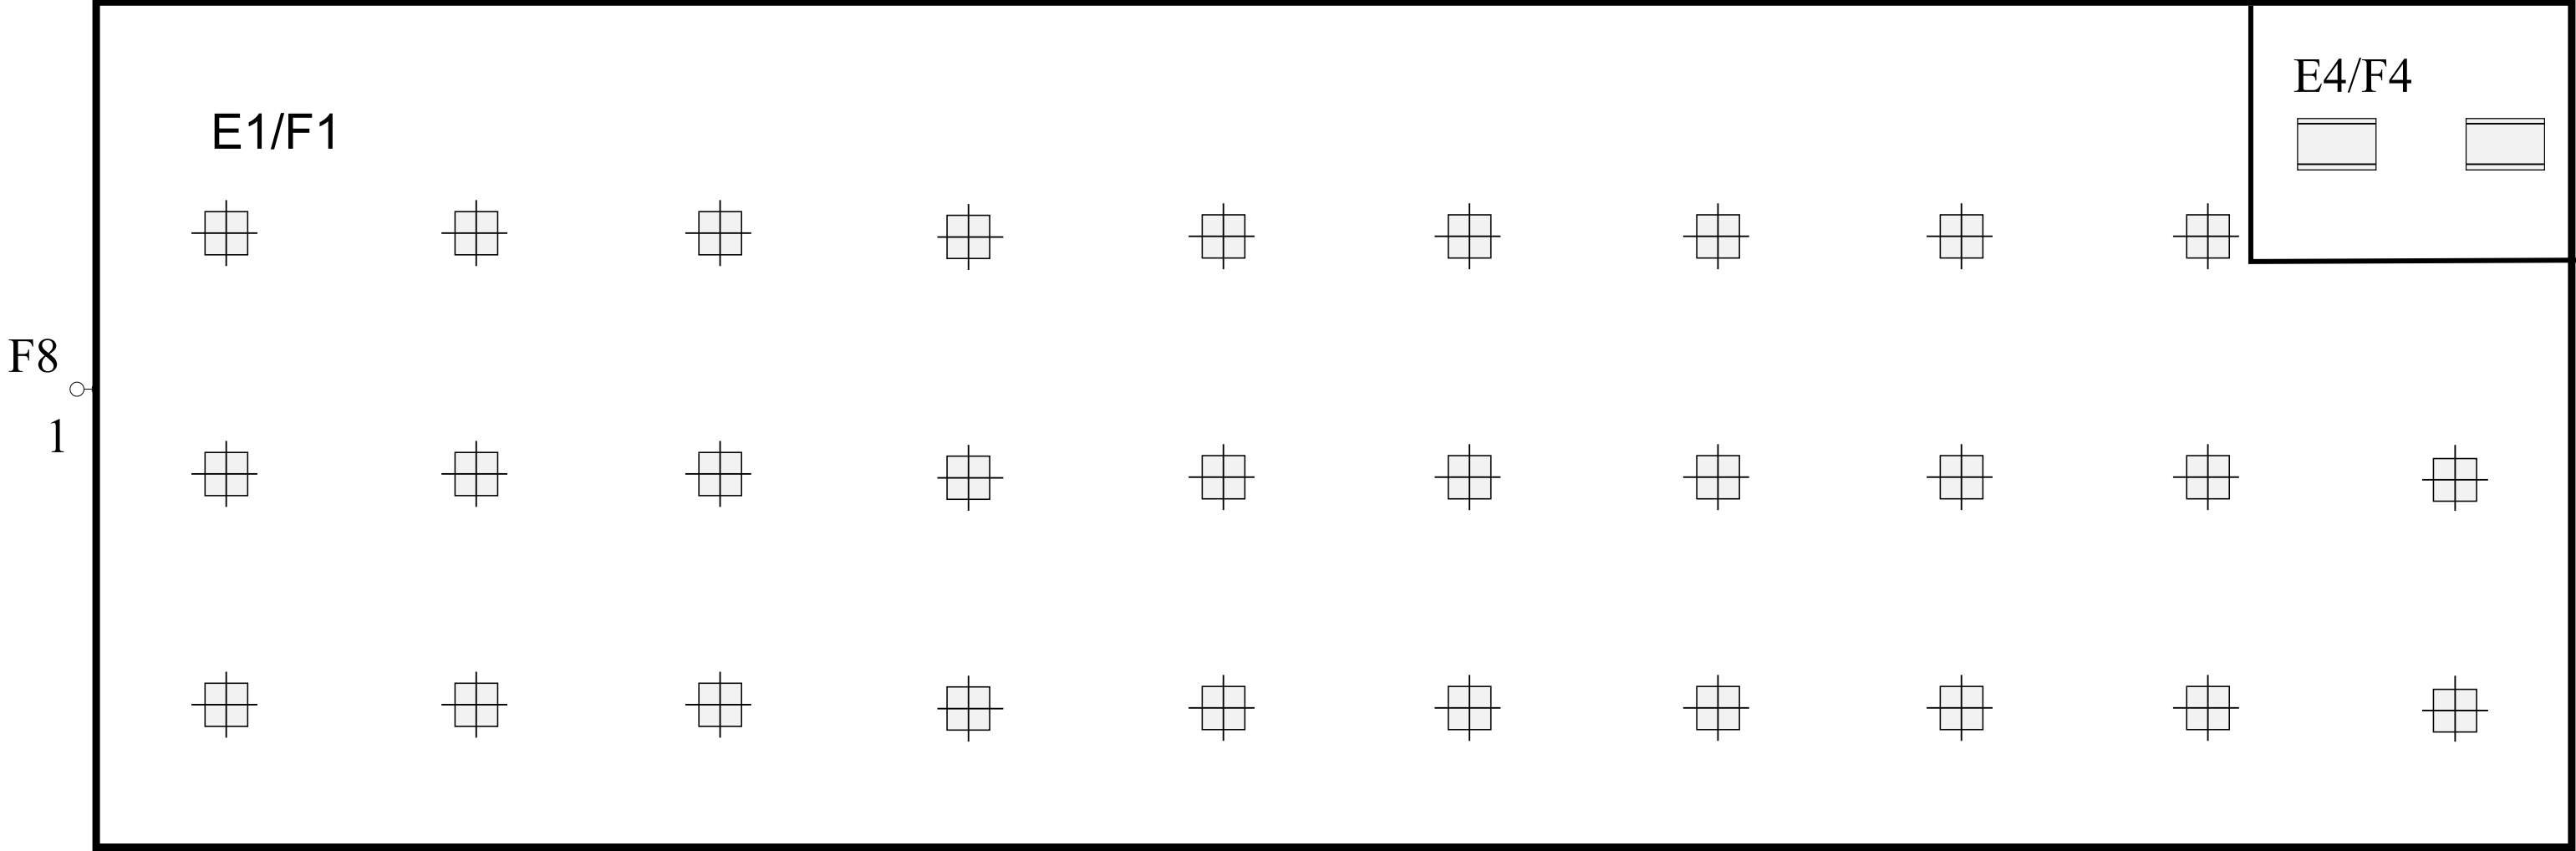


Replace existing light fixtures with new LED fixtures in accordance with the fixture schedule on page 27

1 - Incremental light fixture, location to be field coordinated with Site Director, contractor to field verify wire pathway

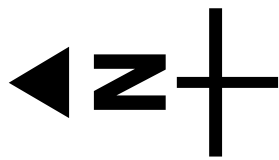


Site:	East barn	Drawing: FP-EB001	Project: FP LED lighting	Drawn: JWF	Notes:	Jefferson County Fair Park 503 N Jackson St. Jefferson, WI 53549
Title:	Interior lighting layout	Scale:NDS	Date: 12/8/2025	Rev: A		

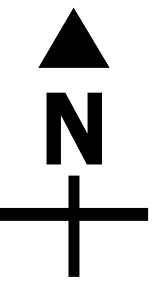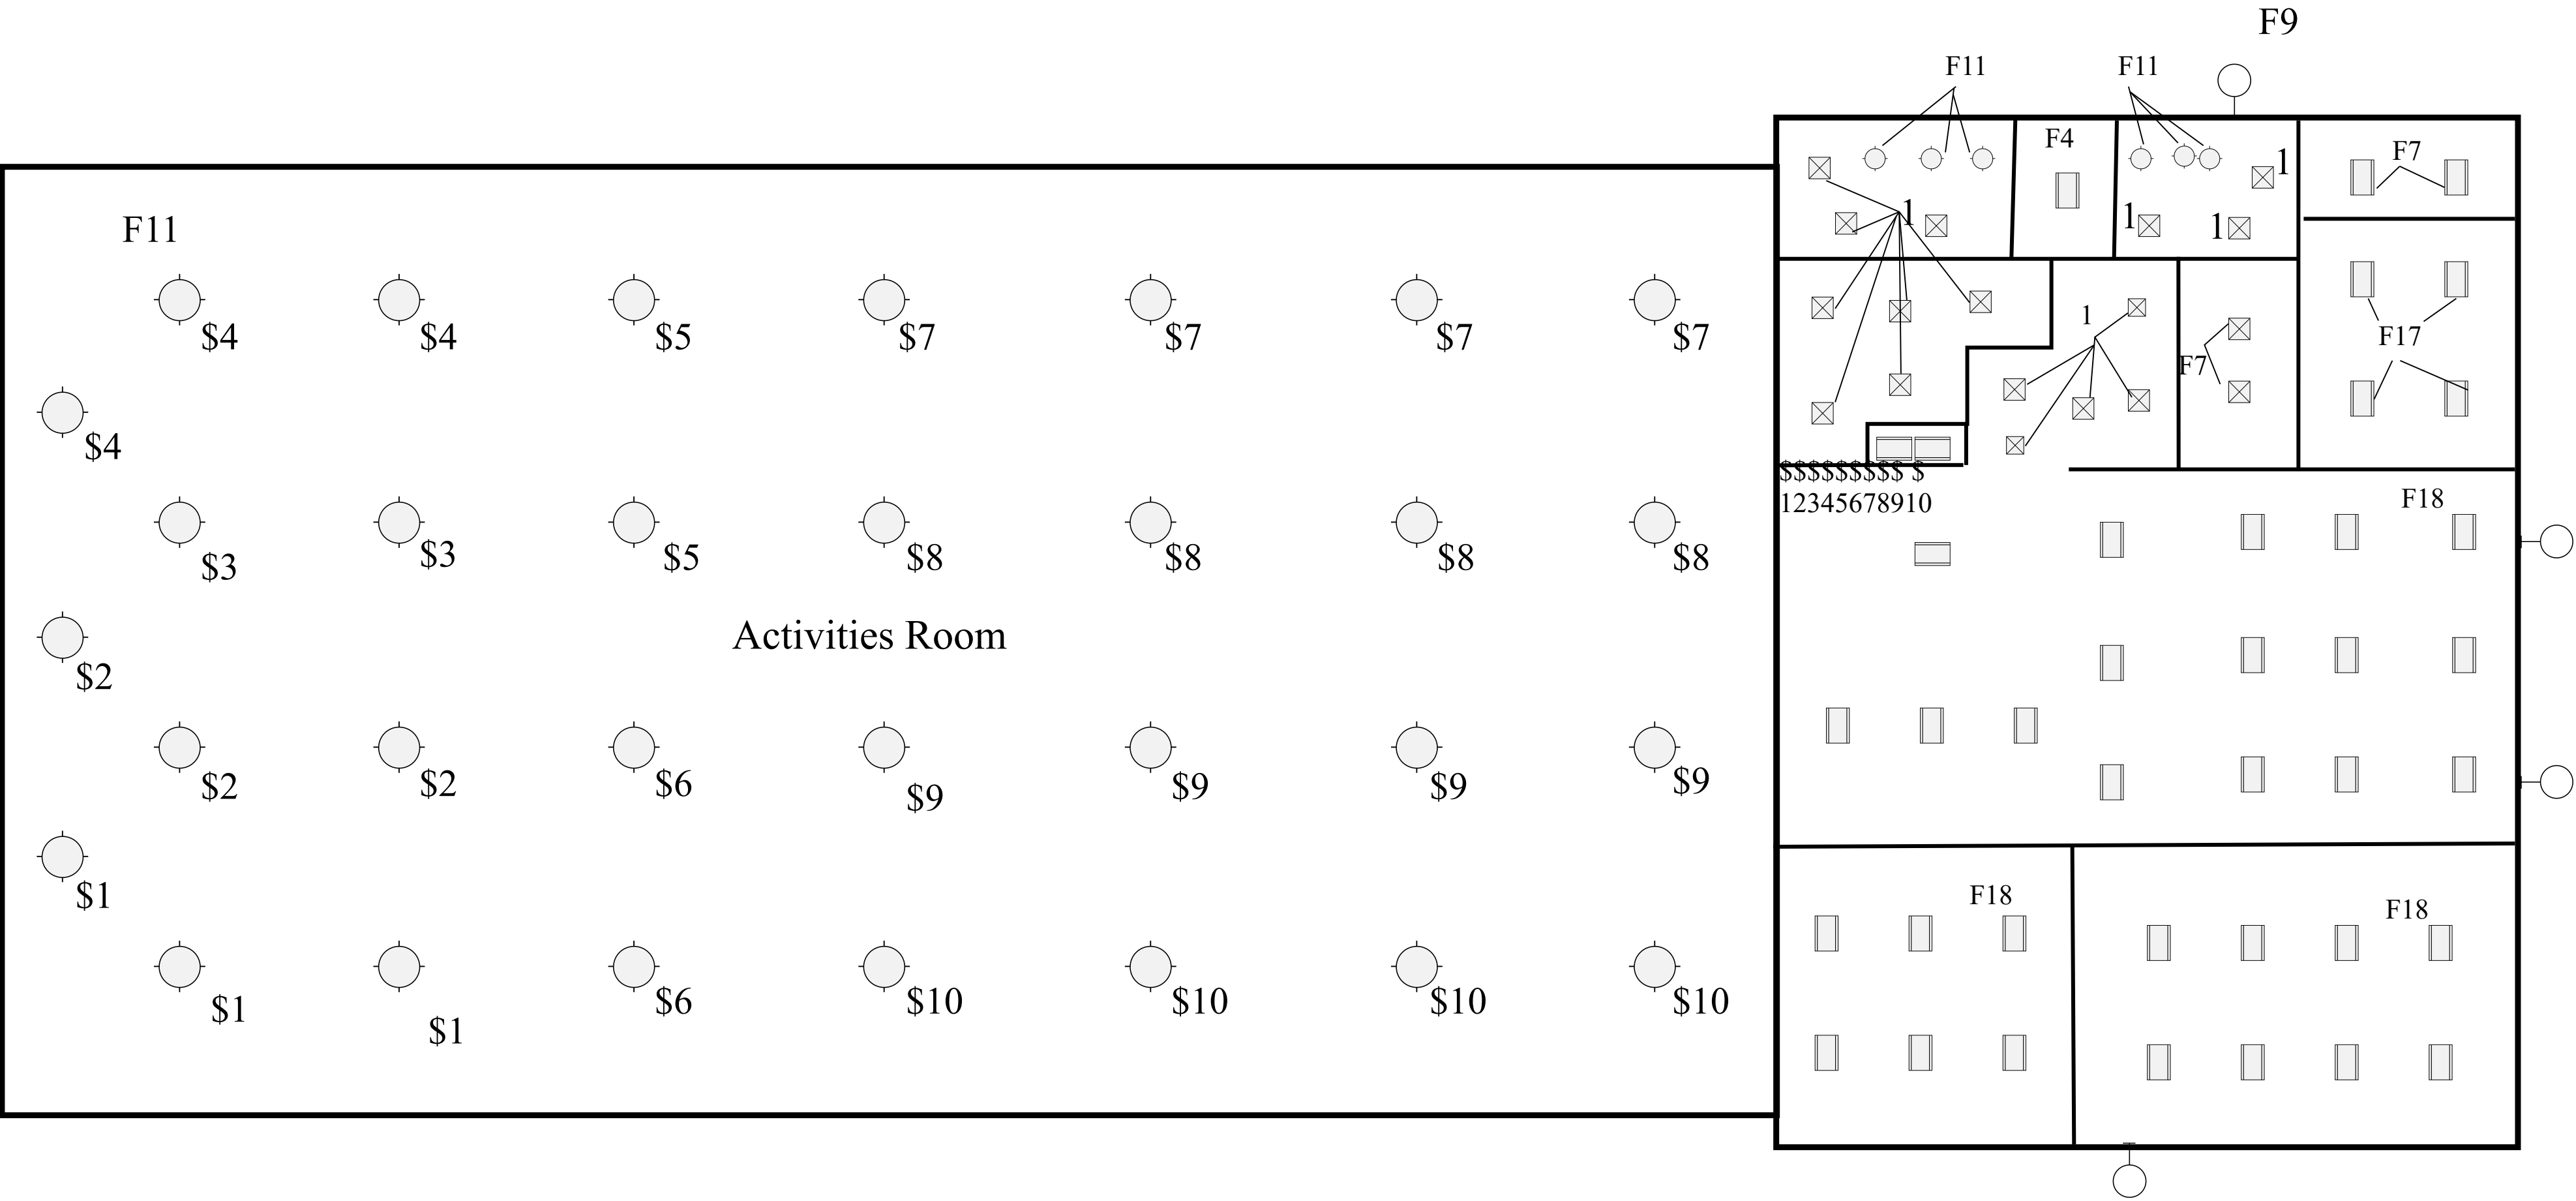


Alternate #02: Activity Center Reconfigure / Dimming Enhancements
Provide deduct alternate to leave this space as is with no work completed.
Switching for these fixtures is intended to be have dimming capability
1 - Existing fixtures to remain

Site:	Activity Center / Office	Drawing: FP-AC001	Project: FP LED lighting	Drawn: JWF	Notes:	Jefferson County Fair Park 503 N Jackson St. Jefferson, WI 53549
Title:	Interior lighting layout	Scale: NDS	Date: 12/8/2025	Rev: A		

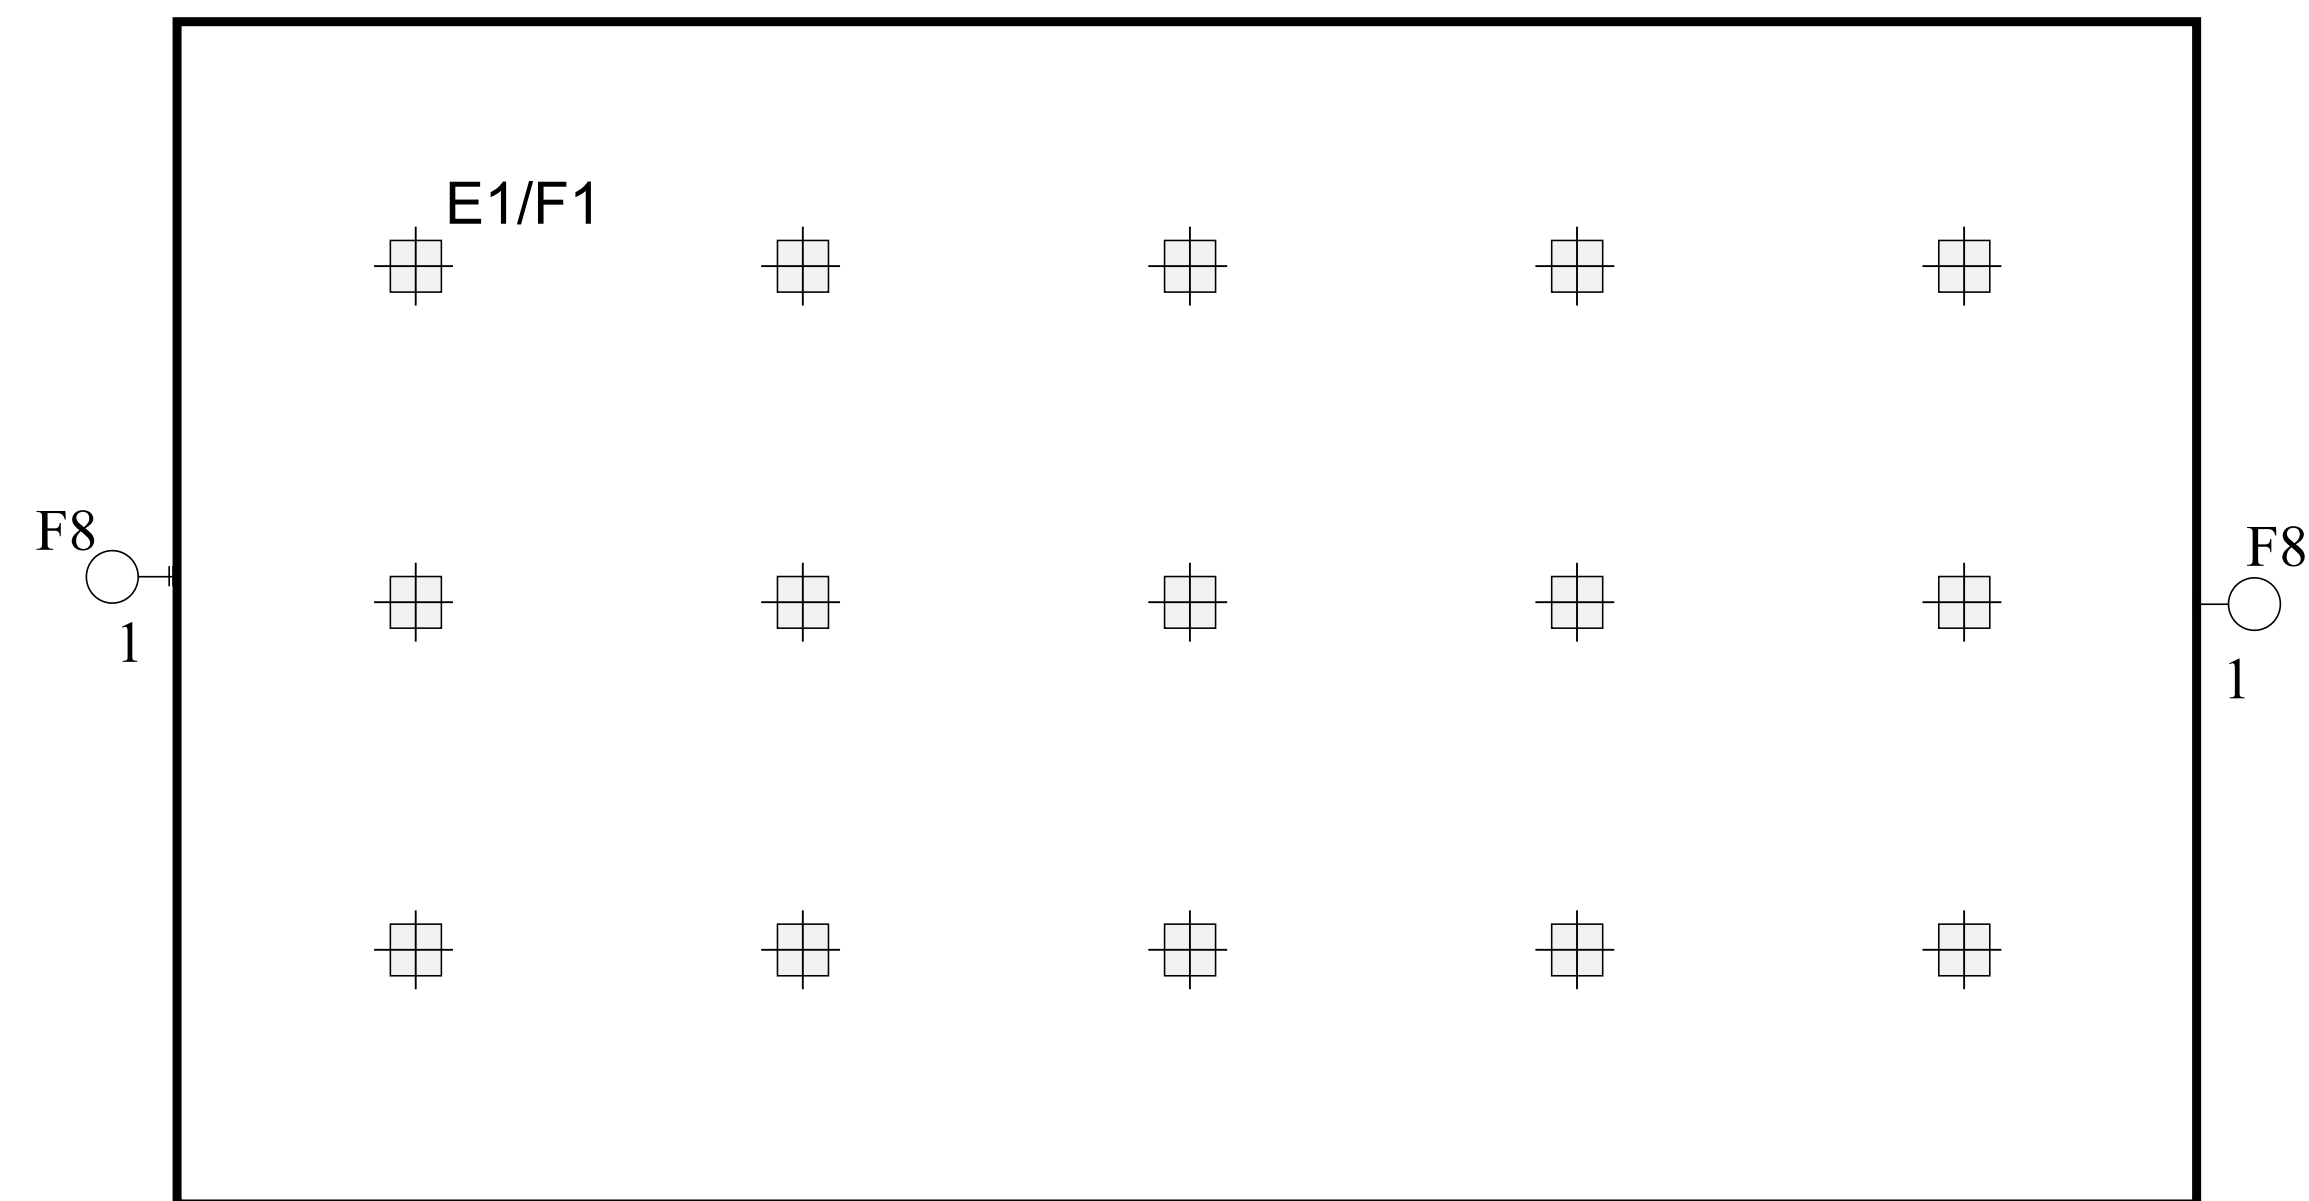


Replace existing light fixtures with new LED fixtures in accordance with the fixture schedule on page 27


1 - Incremental light fixture, location to be field coordinated with Site Director, contractor
to field verify wire pathway

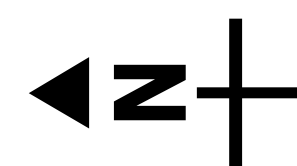

Site:	Poultry barn	Drawing: FP-PB001	Project: FP LED lighting	Drawn: JWF	Notes:	Jefferson County Fair Park 503 N Jackson St. Jefferson, WI 53549
Title:	Interior lighting layout	Scale: NDS	Date: 12/8/2025	Rev: A		

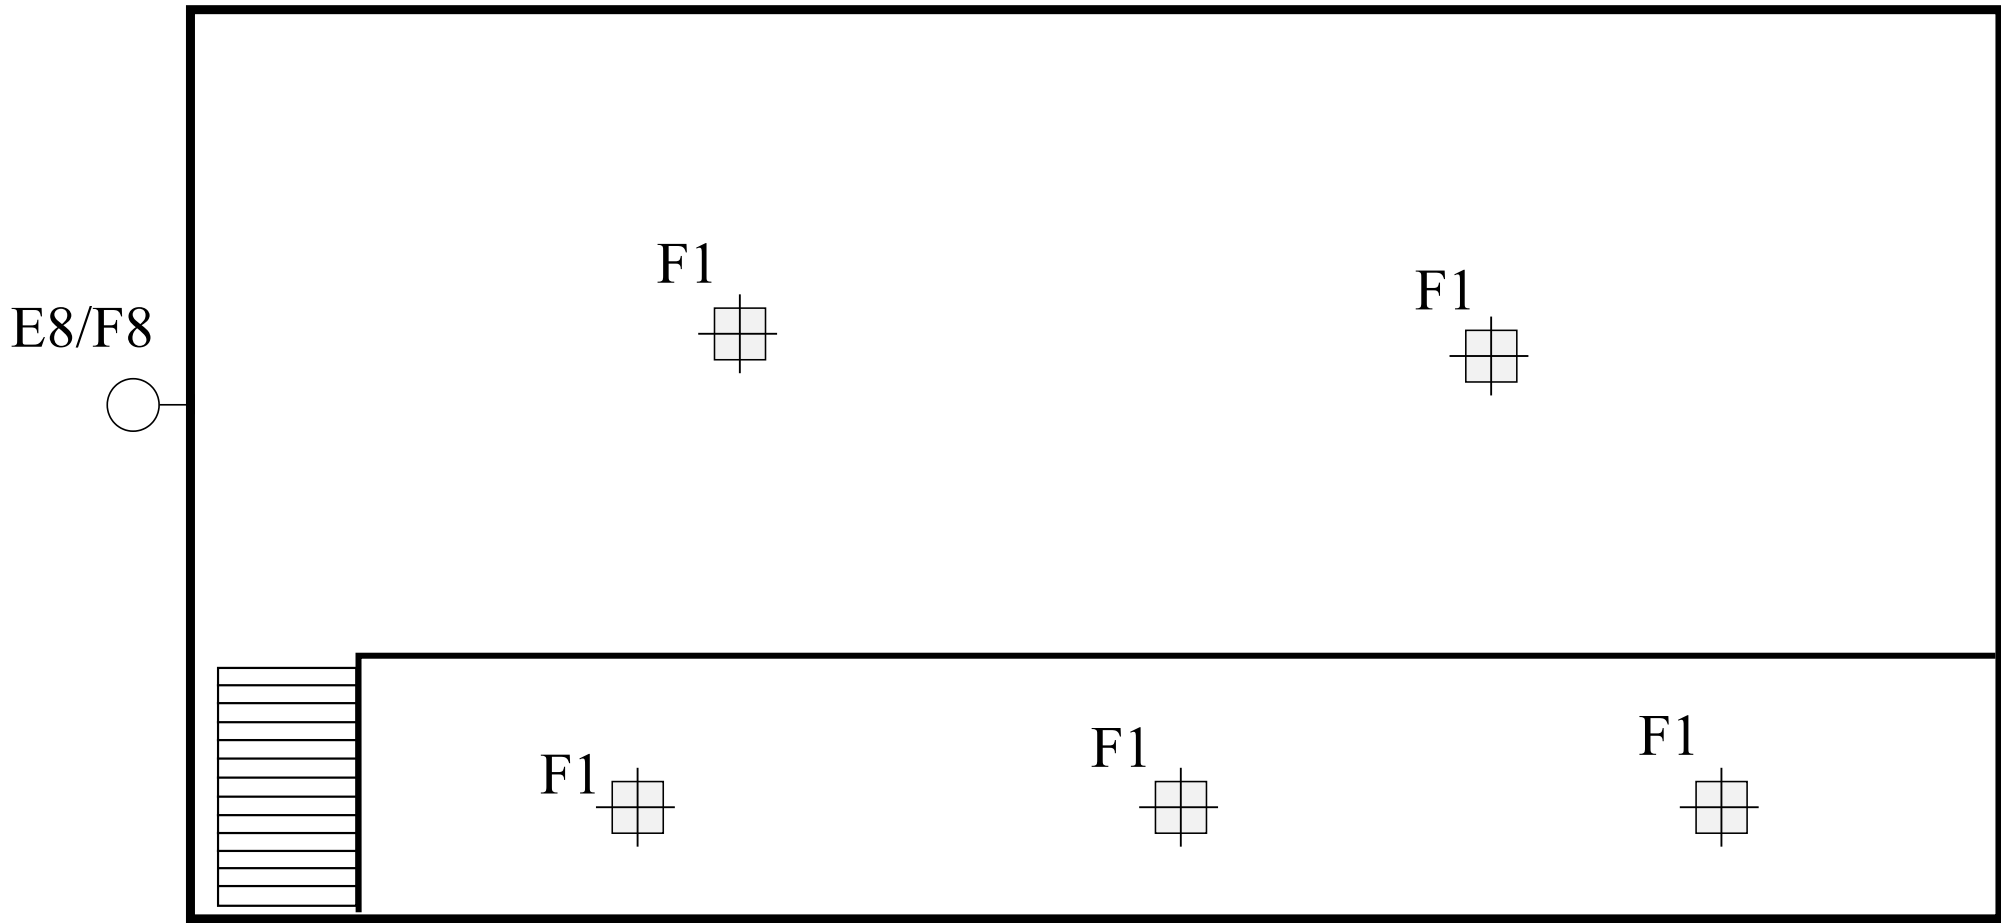


Roof and top side of mezzanine

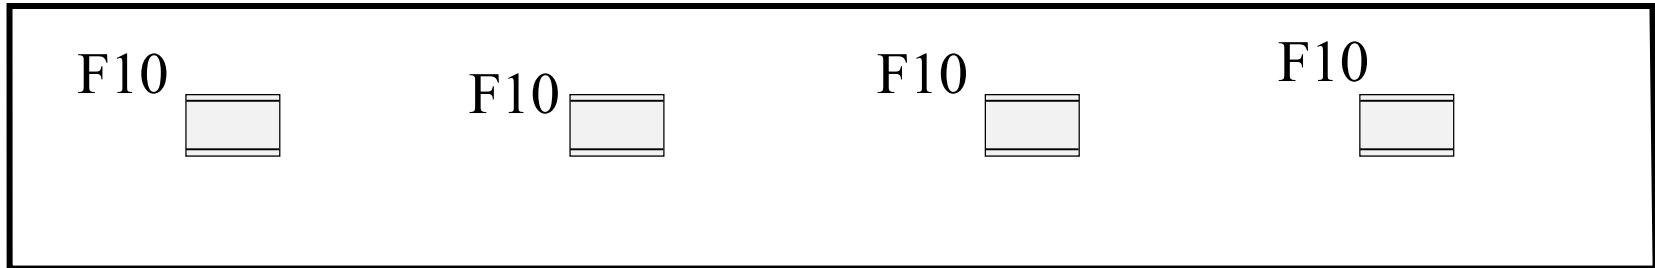


Bottom side of mezzanine


Replace existing light fixtures with new LED fixtures in accordance with the fixture schedule on page 27

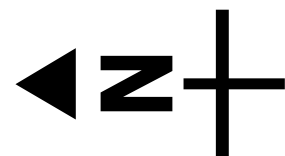



Site:	Storage Building	Drawing: FP-STB001	Project: FP LED lighting	Drawn: JWF	Notes:	Jefferson County Fair Park 503 N Jackson St. Jefferson, WI 53549
Title:	Interior lighting layout	Scale: NDS	Date: 12/8/2025	Rev: A		

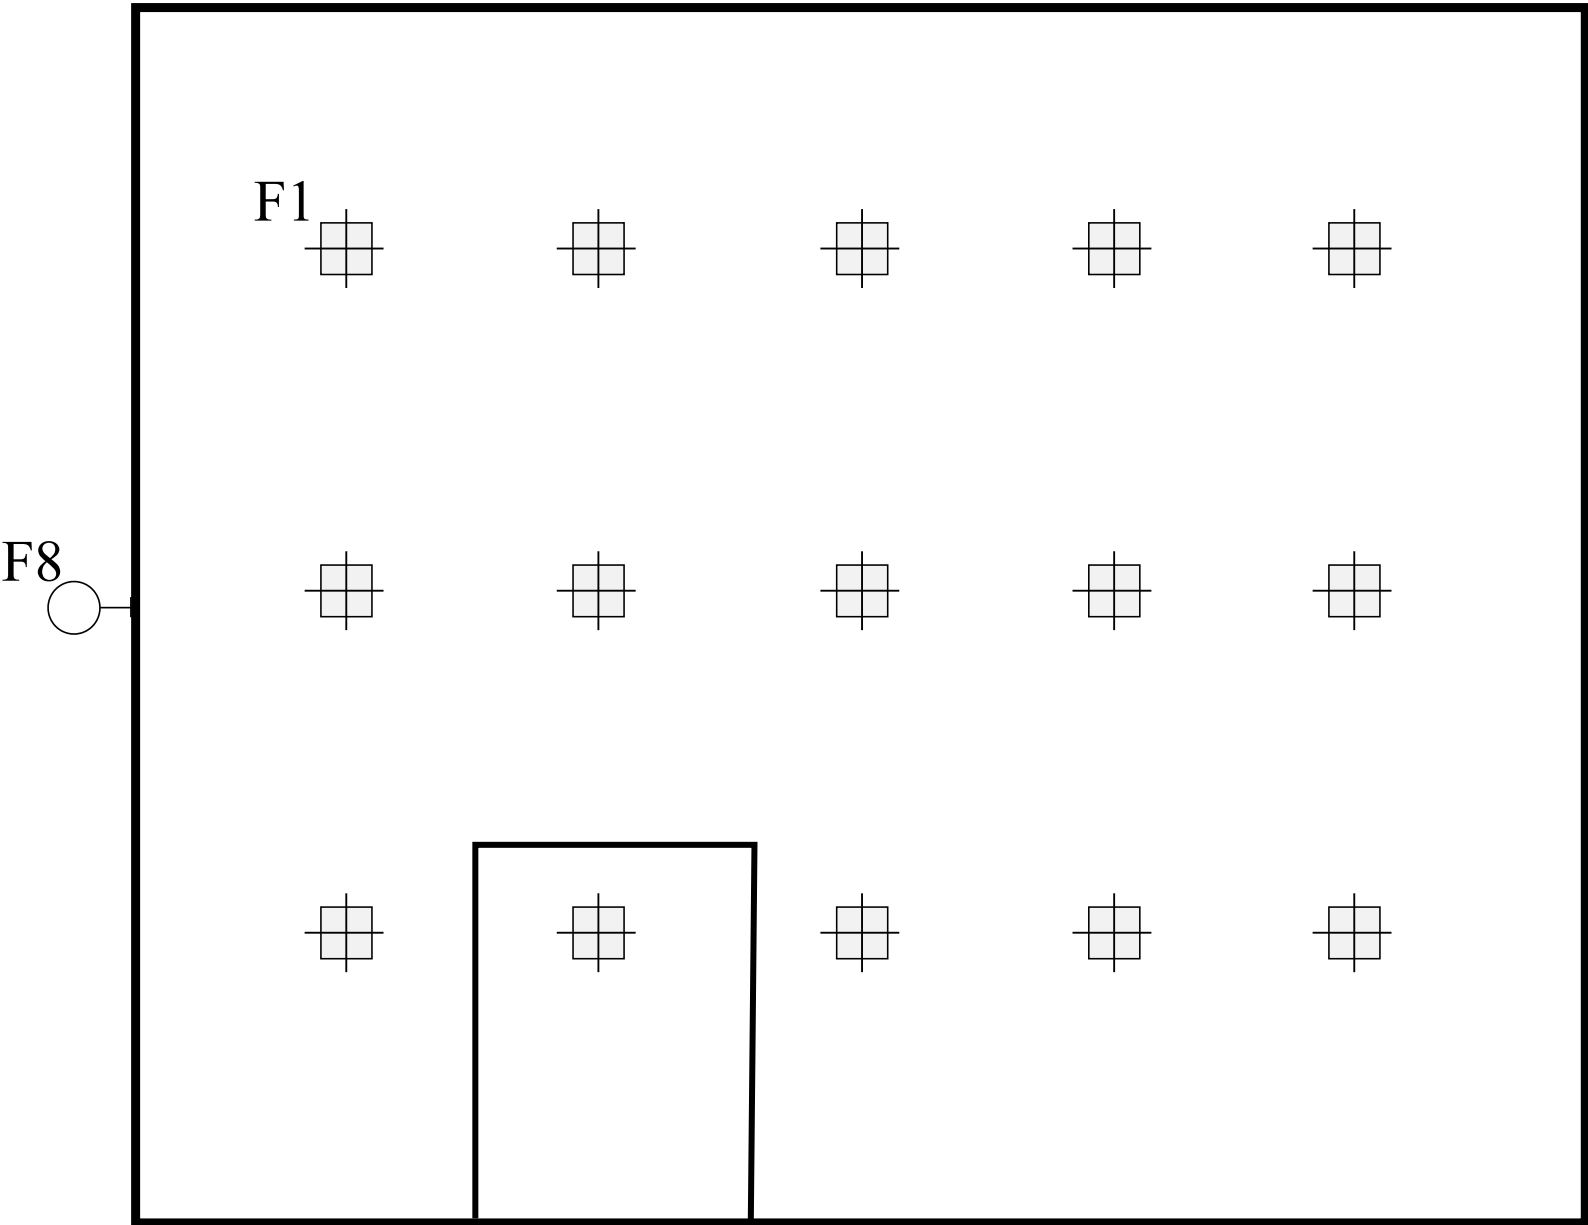

Replace existing light fixtures with new LED fixtures in accordance with the fixture schedule on page 27

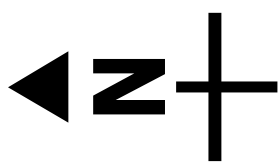


Site: Maintenance Building	Drawing: FP-MAI001	Project: FP LED lighting	Drawn: JWF	Notes:	Jefferson County Fair Park 503 N Jackson St. Jefferson, WI 53549
Title: Interior lighting layout	Scale: NDS	Date: 12/8/2025	Rev: A		

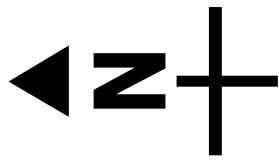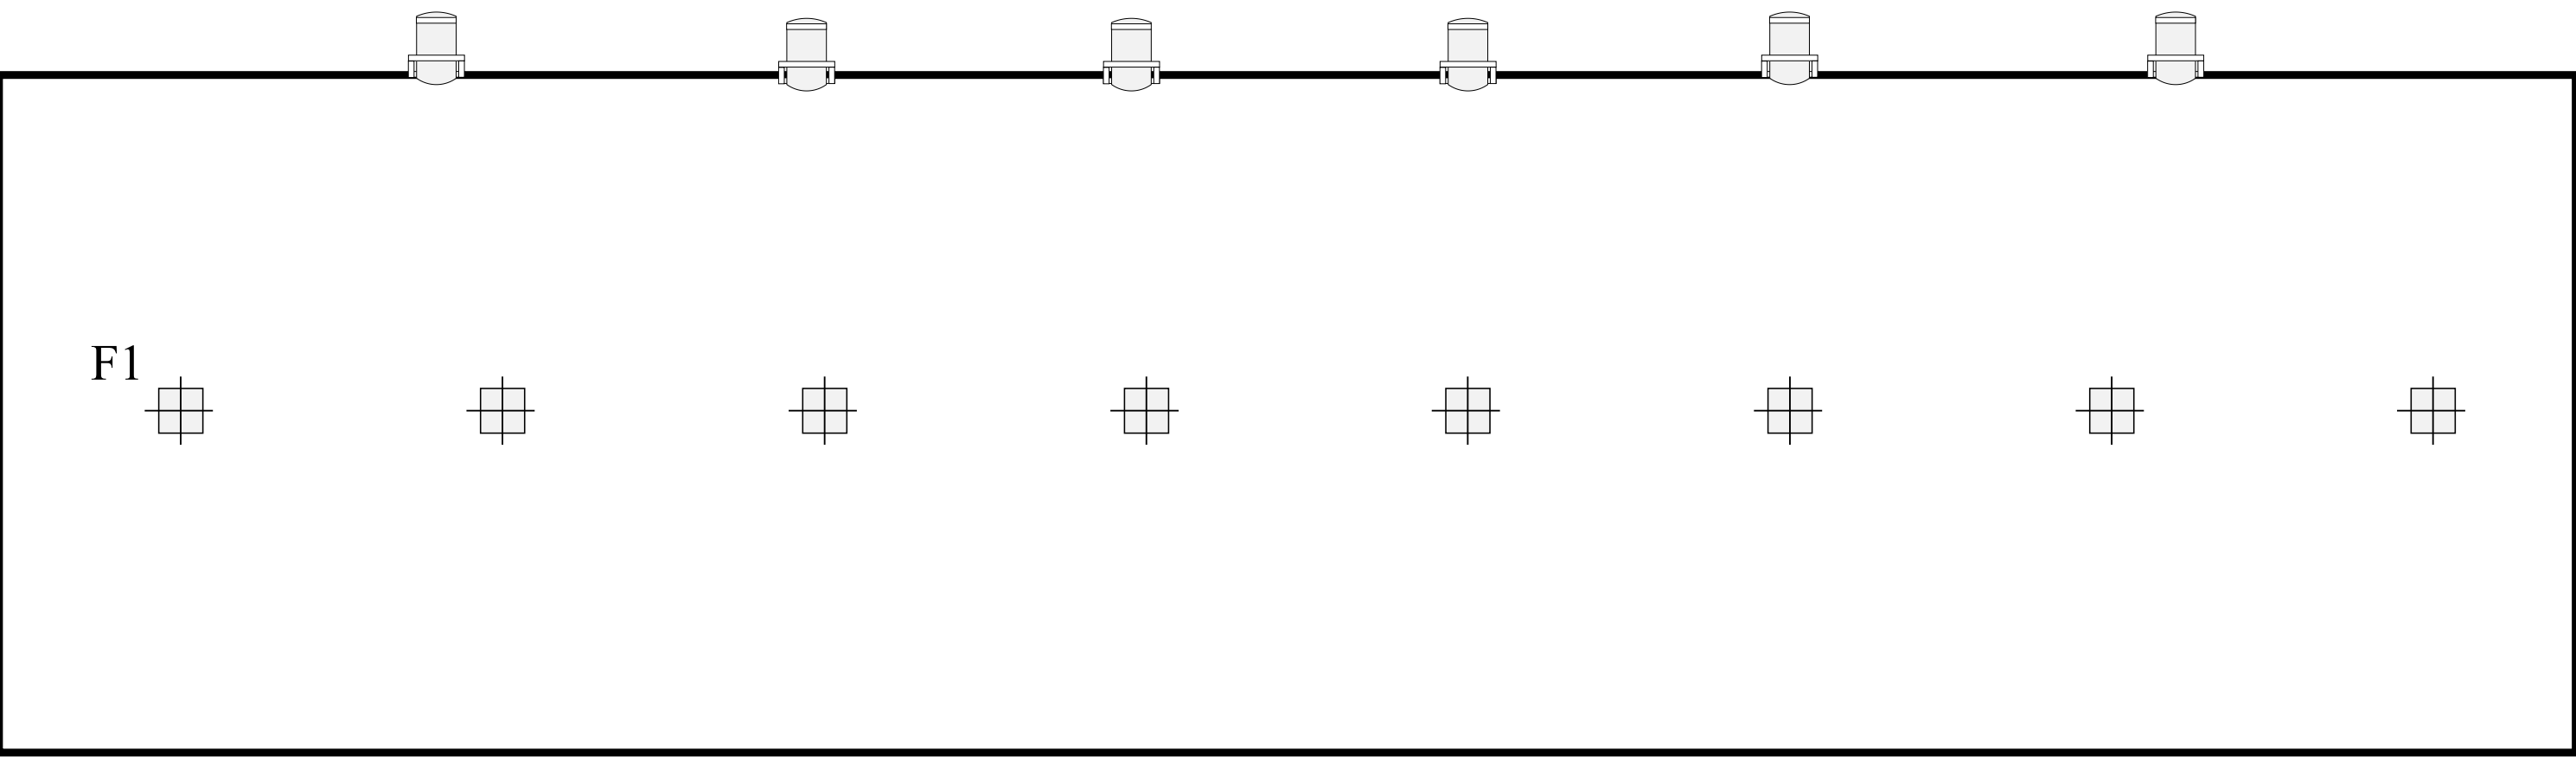

Replace existing light fixtures with new LED fixtures in accordance with the fixture schedule on page 27



Site:	Grand Stands	Drawing: FP-GS001	Project: FP LED lighting	Drawn: JWF	Notes:	Jefferson County Fair Park 503 N Jackson St. Jefferson, WI 53549
Title:	Interior lighting layout	Scale: NDS	Date: 12/8/2025	Rev: A		

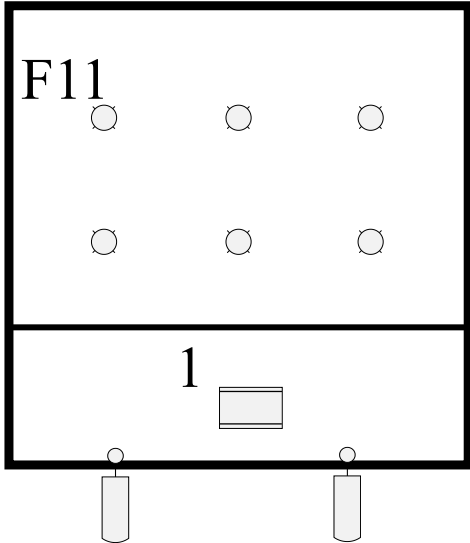

Replace existing light fixtures with new LED fixtures in accordance with the fixture schedule on page 27

1 - Existing to remain


Site:	Sheriff Building	Drawing:	FP-SHB001	Project:	FP LED lighting	Drawn:	JWF	Notes:	Jefferson County Fair Park 503 N Jackson St. Jefferson, WI 53549
Title:	Interior lighting layout	Scale:	NDS	Date:	12/8/2025	Rev:	A		

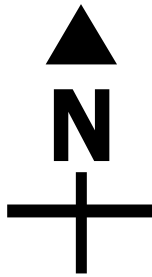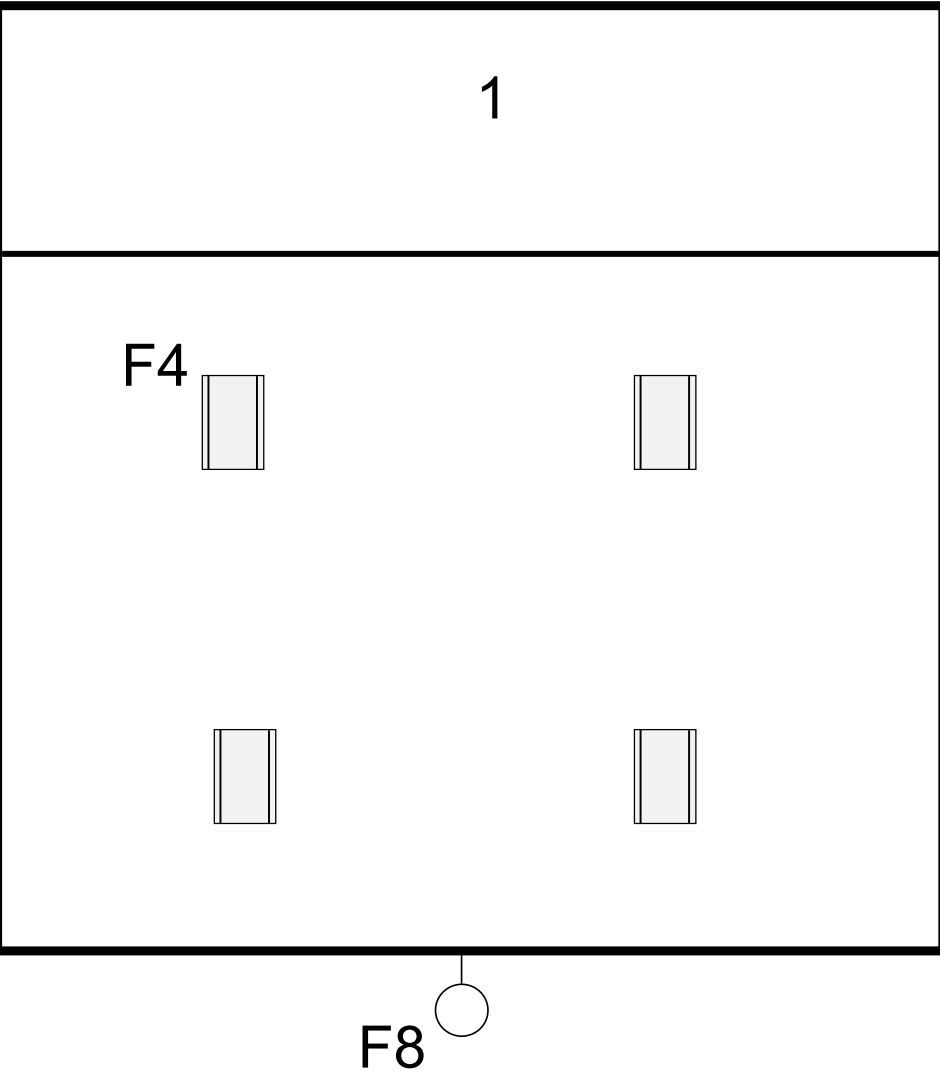

Replace existing light fixtures with new LED fixtures in accordance with the fixture schedule on page 27



1 - Existing to remain

Site:	Kiwanis Building	Drawing:	FP-KB001	Project:	FP LED lighting	Drawn:	JWF	Notes:	Jefferson County Fair Park 503 N Jackson St. Jefferson, WI 53549
Title:	Interior lighting layout	Scale:	NDS	Date:	12/8/2025	Rev:	A		

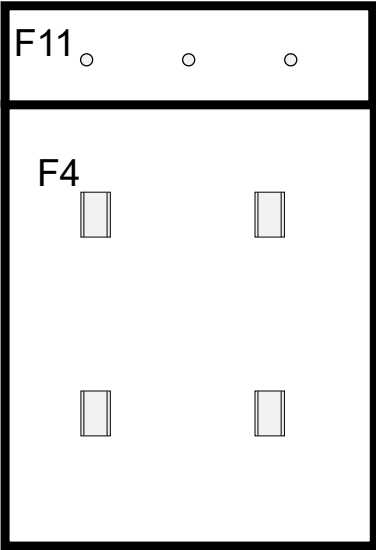

Replace existing light fixtures with new LED fixtures in accordance with the fixture schedule on page 27


Site: Legacy office structure	Drawing: FP-LOS001	Project: FP LED lighting	Drawn: JWF	Notes:	Jefferson County Fair Park 503 N Jackson St. Jefferson, WI 53549
Title: Interior lighting layout	Scale: NDS	Date: 12/8/2025	Rev: A		

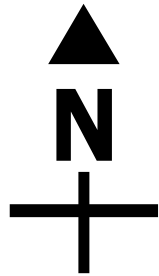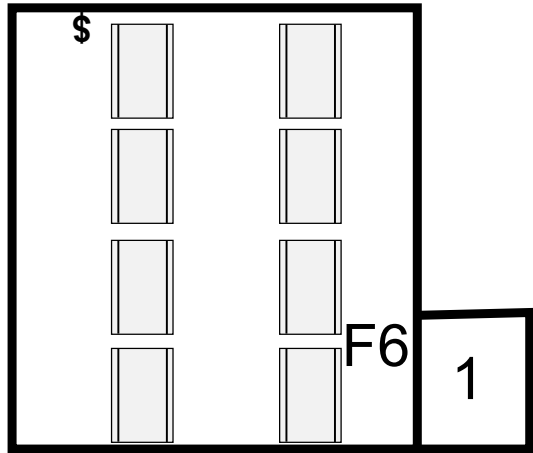

Replace existing light fixtures with new LED fixtures in accordance with the fixture schedule on page 27


1 - Existing to remain

Site: Storage B	Drawing: FP-STBB001	Project: FP LED lighting	Drawn: JWF	Notes:	Jefferson County Fair Park 503 N Jackson St. Jefferson, WI 53549
Title: Interior lighting layout	Scale: NDS	Date: 12//8/2025	Rev: A		

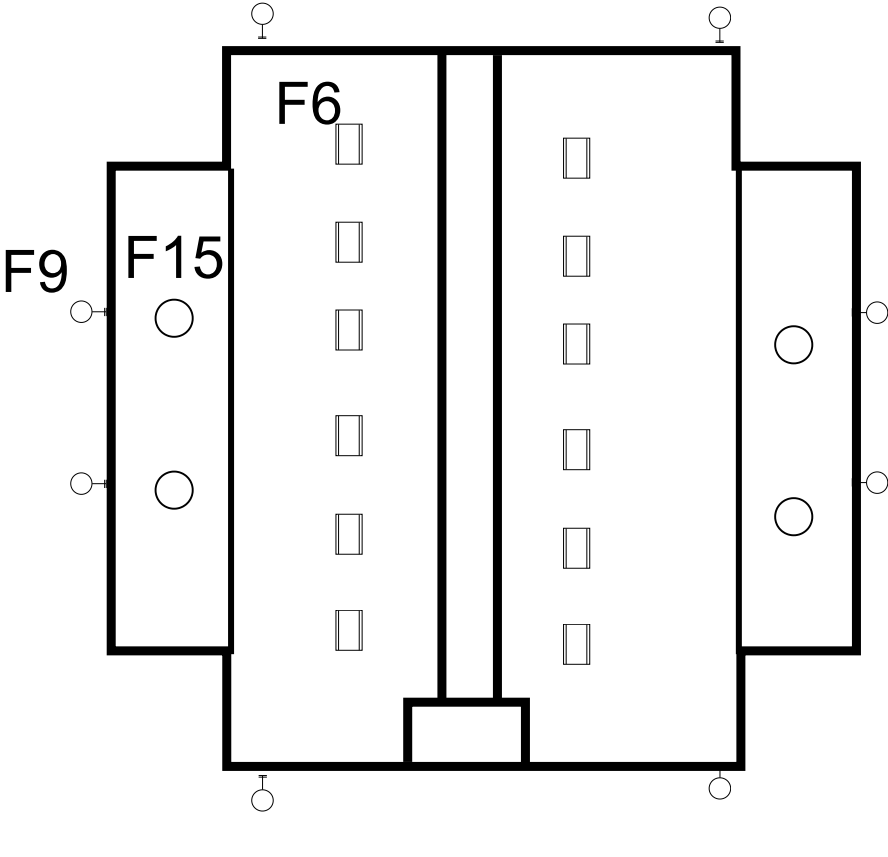



Replace existing light fixtures with new LED fixtures in accordance with the fixture schedule on page 27

Site: Rest Room #01	Drawing: FP-RR1001	Project: FP LED lighting	Drawn: JWF	Notes:	Jefferson County Fair Park 503 N Jackson St. Jefferson, WI 53549
Title: Interior lighting layout	Scale: NDS	Date: 12/8/2025	Rev: A		

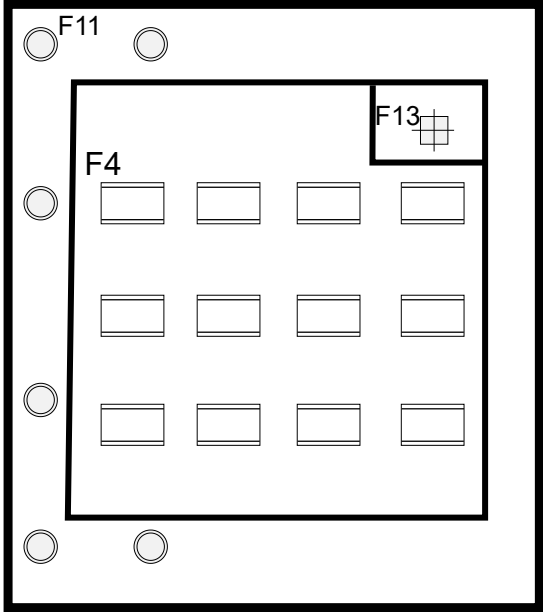


Replace existing light fixtures with new LED fixtures in accordance with the fixture schedule on page 27

Site: Concession	Drawing: FP-CB001	Project: FP LED lighting	Drawn: JWF	Notes:	Jefferson County Fair Park 503 N Jackson St. Jefferson, WI 53549
Title: Interior lighting layout	Scale: NDS	Date: 12/8/2025	Rev: A		

 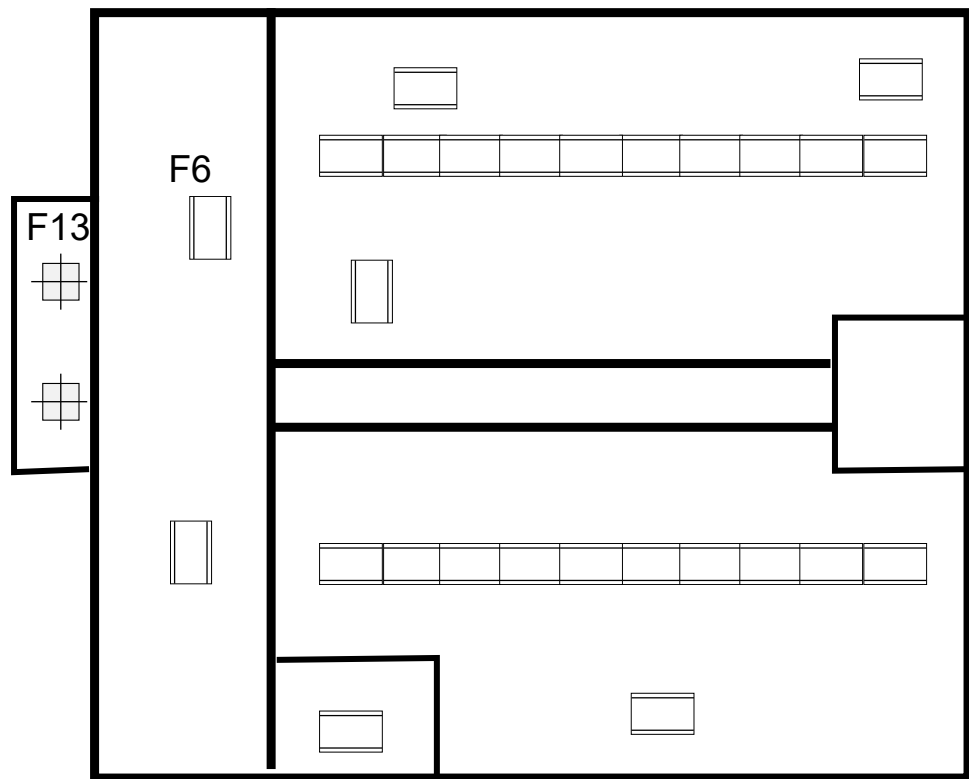

Replace existing light fixtures with new LED fixtures in accordance with the fixture schedule on page 27

Site: Rest room #04	Drawing: FP-RR4001	Project: FP LED lighting	Drawn: JWF	Notes:	Jefferson County Fair Park 503 N Jackson St. Jefferson, WI 53549
Title: Interior lighting layout	Scale: NDS	Date: 12/8/2025	Rev: A		

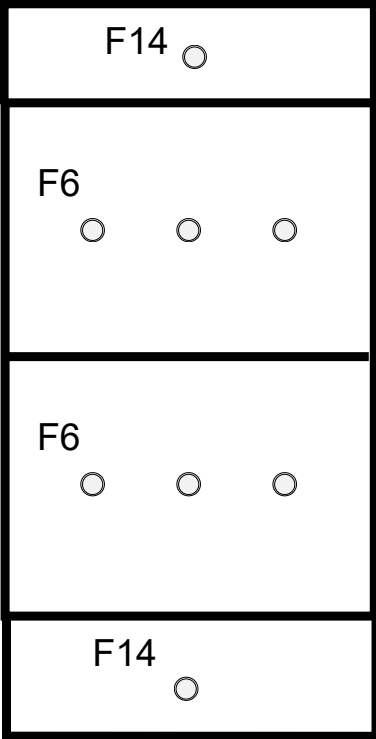

Replace existing light fixtures with new LED fixtures in accordance with the fixture schedule on page x

Site: Rest room #02	Drawing: FP-RR2001	Project: FP LED lighting	Drawn: JWF	Notes:	Jefferson County Fair Park 503 N Jackson St. Jefferson, WI 53549
Title: Interior lighting layout	Scale: NDS	Date: 12/8/2025	Rev: A		