



THIS DOCUMENT, THE SPECIFICATIONS, AND THE DRAWINGS ARE THE PROPERTY OF Durrant Engineering, Inc. and are to be used only for the project and location specified herein. No part of this document may be reproduced or transmitted in any form or by any means electronic or mechanical, including photocopying, recording, or by any information storage and retrieval system, without written permission from Durrant Engineering, Inc. All rights reserved.

DATE: 3/5/01
DRAWN BY: JLN
CHECKED BY: PWB
SHEET CONTENTS:
REFLECTED CEILING PLAN

PLAN NOTES


1. SKYLIGHTS, DRYWALL, METAL BUILDING FRAMING, ETC. BY ALTERNATE BD-A
2. LEAVE EXISTING HORIZONTAL GRITER @ 9'-4"±
3. SUSPEND NEW CEILING ORIGIN.

ROOM NUMBERS AND NAMES

| | |
|------------------------|-------------------------|
| 101 MEN'S SHOWER | 109 WOMEN'S SHOWER |
| 102 NEW LOBBY | 110 WOMEN'S TOILET ROOM |
| 103 STAFF OFFICE | 111 WOMEN'S TOILET ROOM |
| 104 STAFF OFFICE | 112 CORRIDOR |
| 105 MAINTENANCE OFFICE | 113 CORRIDOR |
| 106 MEN'S TOILET ROOM | 114 CORRIDOR |
| 107 MEN'S SHOWER | 115 EXISTING LOBBY |
| 108 VESTIBULE | |

CEILING LEGEND

- 2" x 2" SUSPENDED GRID AND LAY-IN PANEL CEILING SYSTEM REFER TO ROOM FINISH SCHEDULE FOR HEIGHT
- SUSPENDED GYPSUM BOARD CEILING WR GYP IN SHOWER ROOMS.
- NEW GYPSUM BOARD FASTENED TO BOTTOM OF EXISTING CEILING JOISTS.
- RECESSED FLUORESCENT LIGHT FIXTURE REFER TO ELECTRICAL DRAWINGS.
- FLUORESCENT MOUNTED OR SUSPENDED REFER TO ELECTRICAL DRAWINGS
- RECESSED LIGHT FIXTURE REFER TO ELECTRICAL DRAWINGS
- HVAC SUPPLY OR TRANSFER GRILLE REFER TO MECHANICAL DRAWINGS
- HVAC RETURN OR TRANSFER GRILLE REFER TO MECHANICAL DRAWINGS
- HVAC EXHAUST GRILLE REFER TO MECHANICAL DRAWINGS

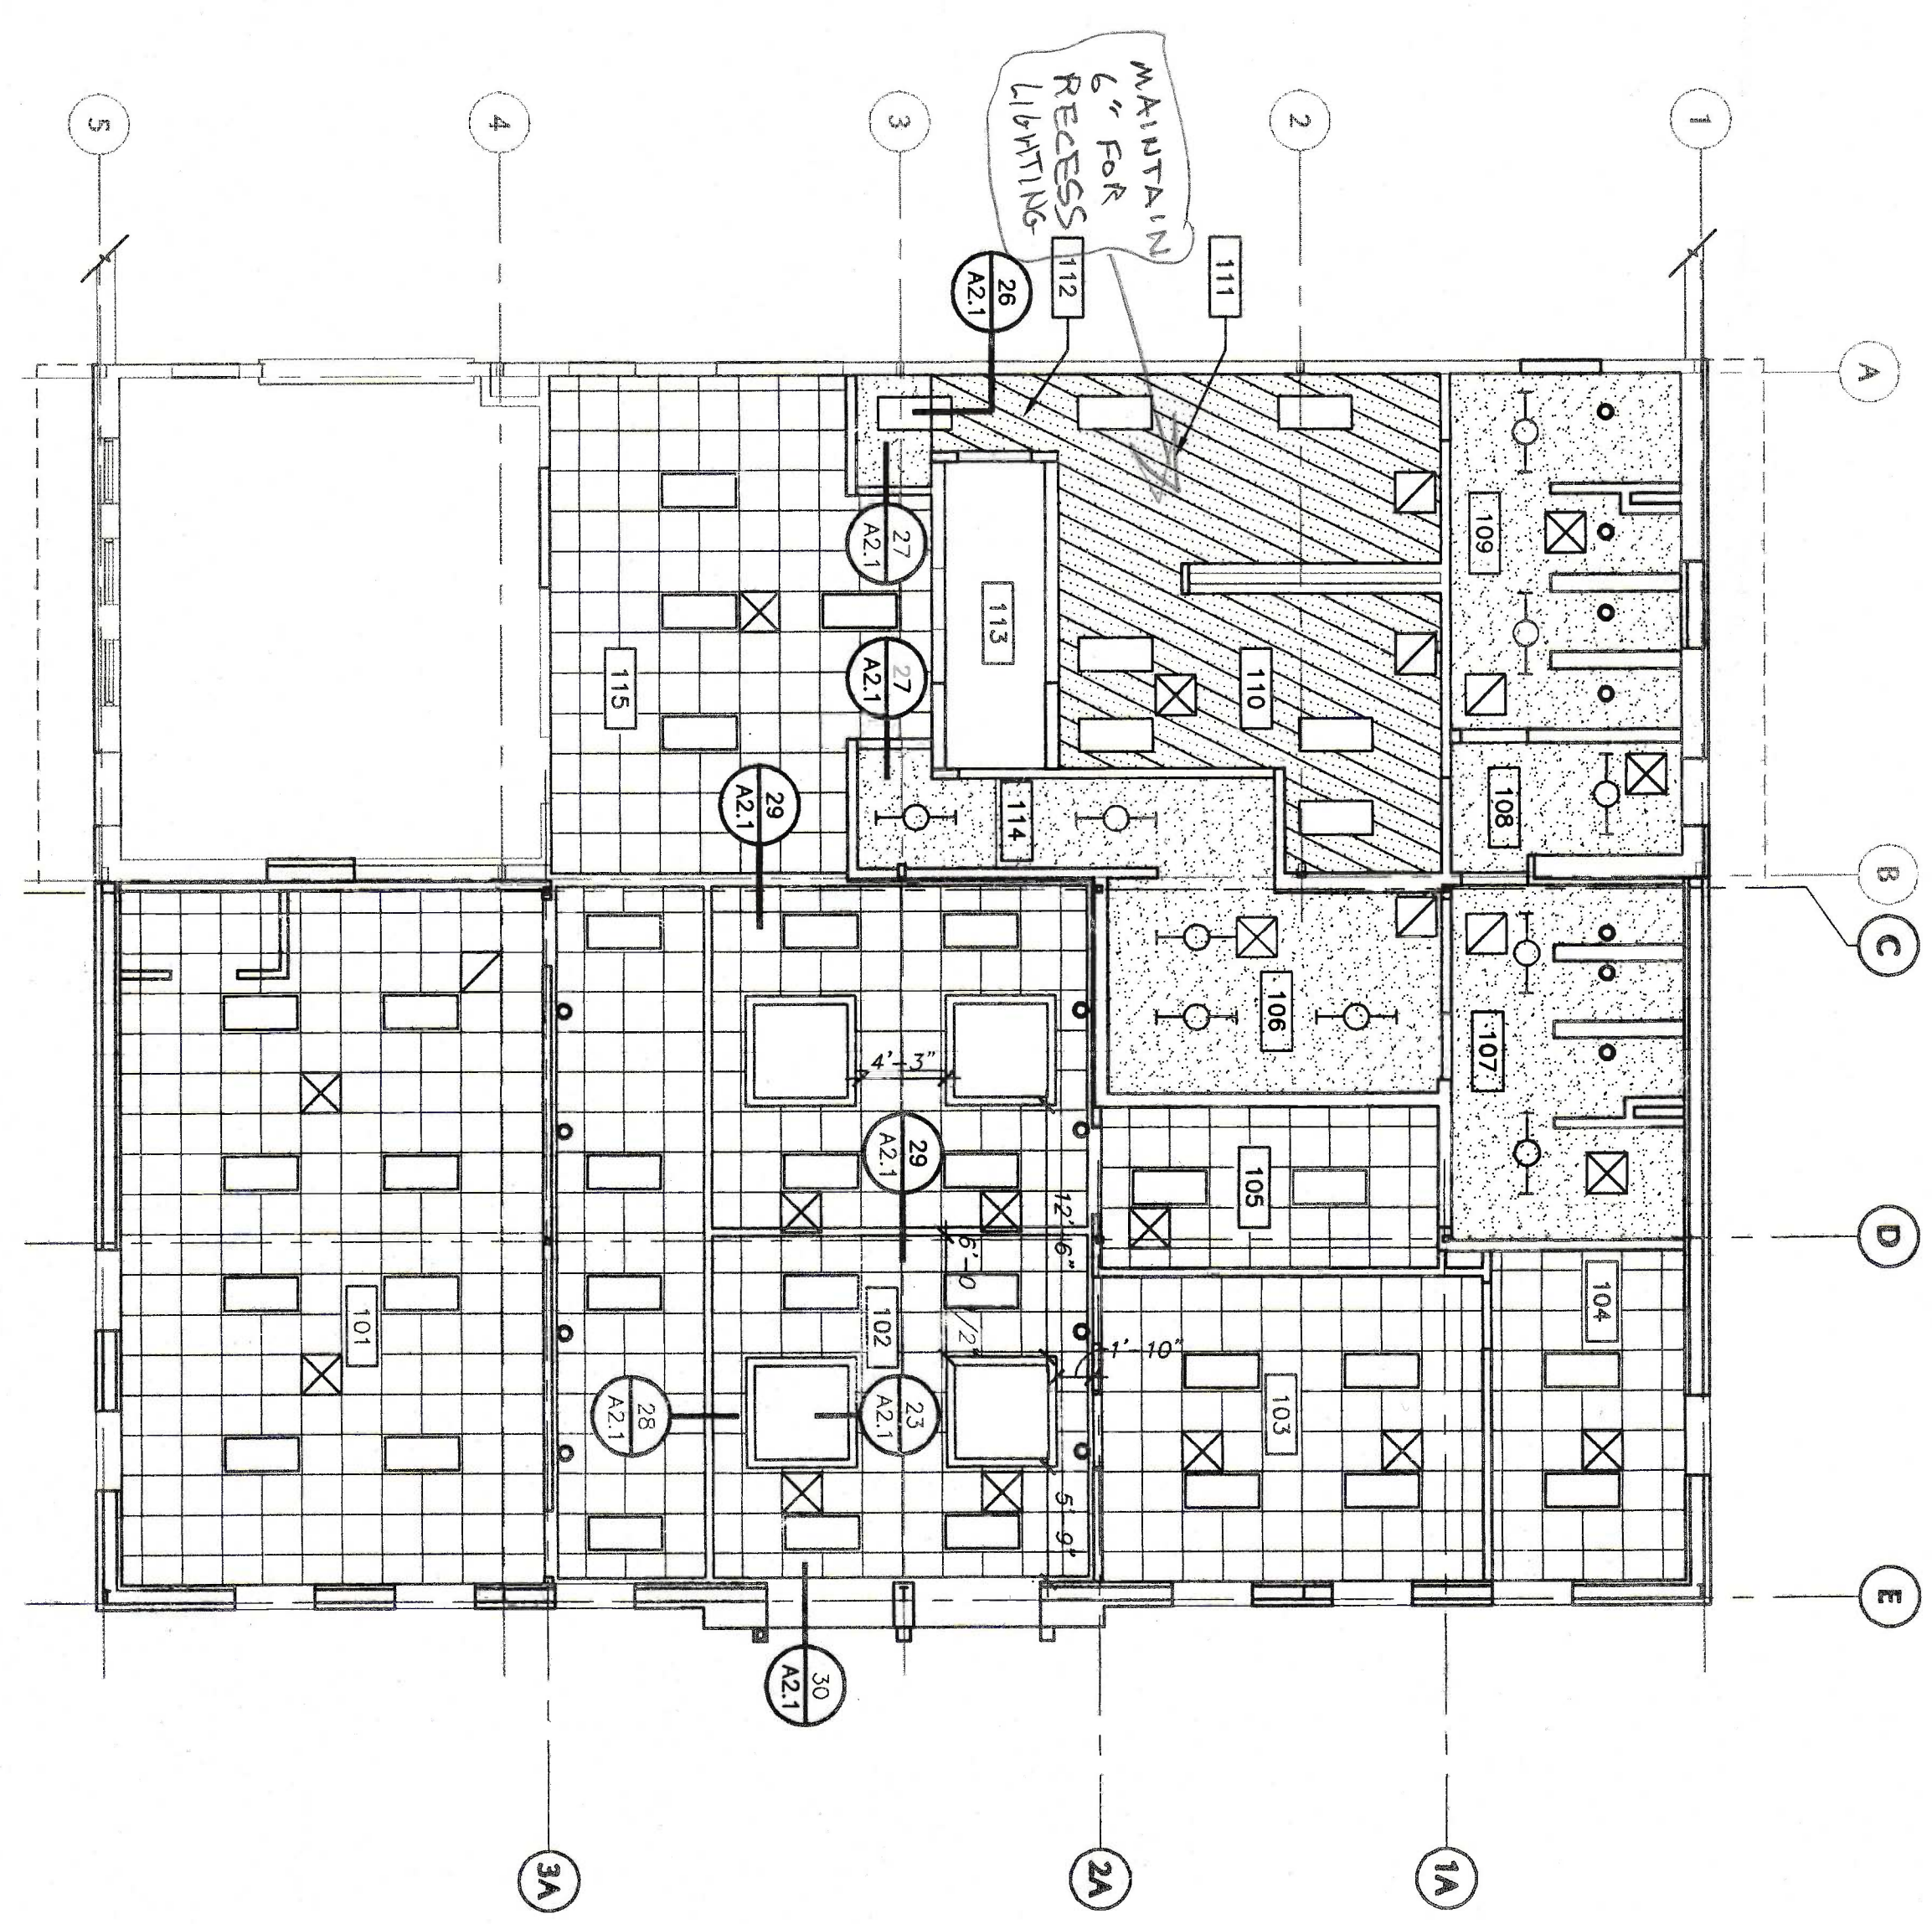

REFLECTED CEILING PLAN
SCALE: 1/8" = 1'-0"

- 26 CEILING CONTROL JOINT
SCALE: 1 1/2" = 1'-0"
- 27 GYP. BOARD BULKHEAD
SCALE: 1 1/2" = 1'-0"
- 28 BULKHEAD DETAIL
SCALE: 1 1/2" = 1'-0"
- 29 GYP. BD. Baffle
SCALE: 1 1/2" = 1'-0"
- 30 GYP. BD. BAND
SCALE: 1 1/2" = 1'-0"
- 23 GYP. BD. @ SKYLIGHT (A.L.T. BID)
SCALE: N.T.S.