
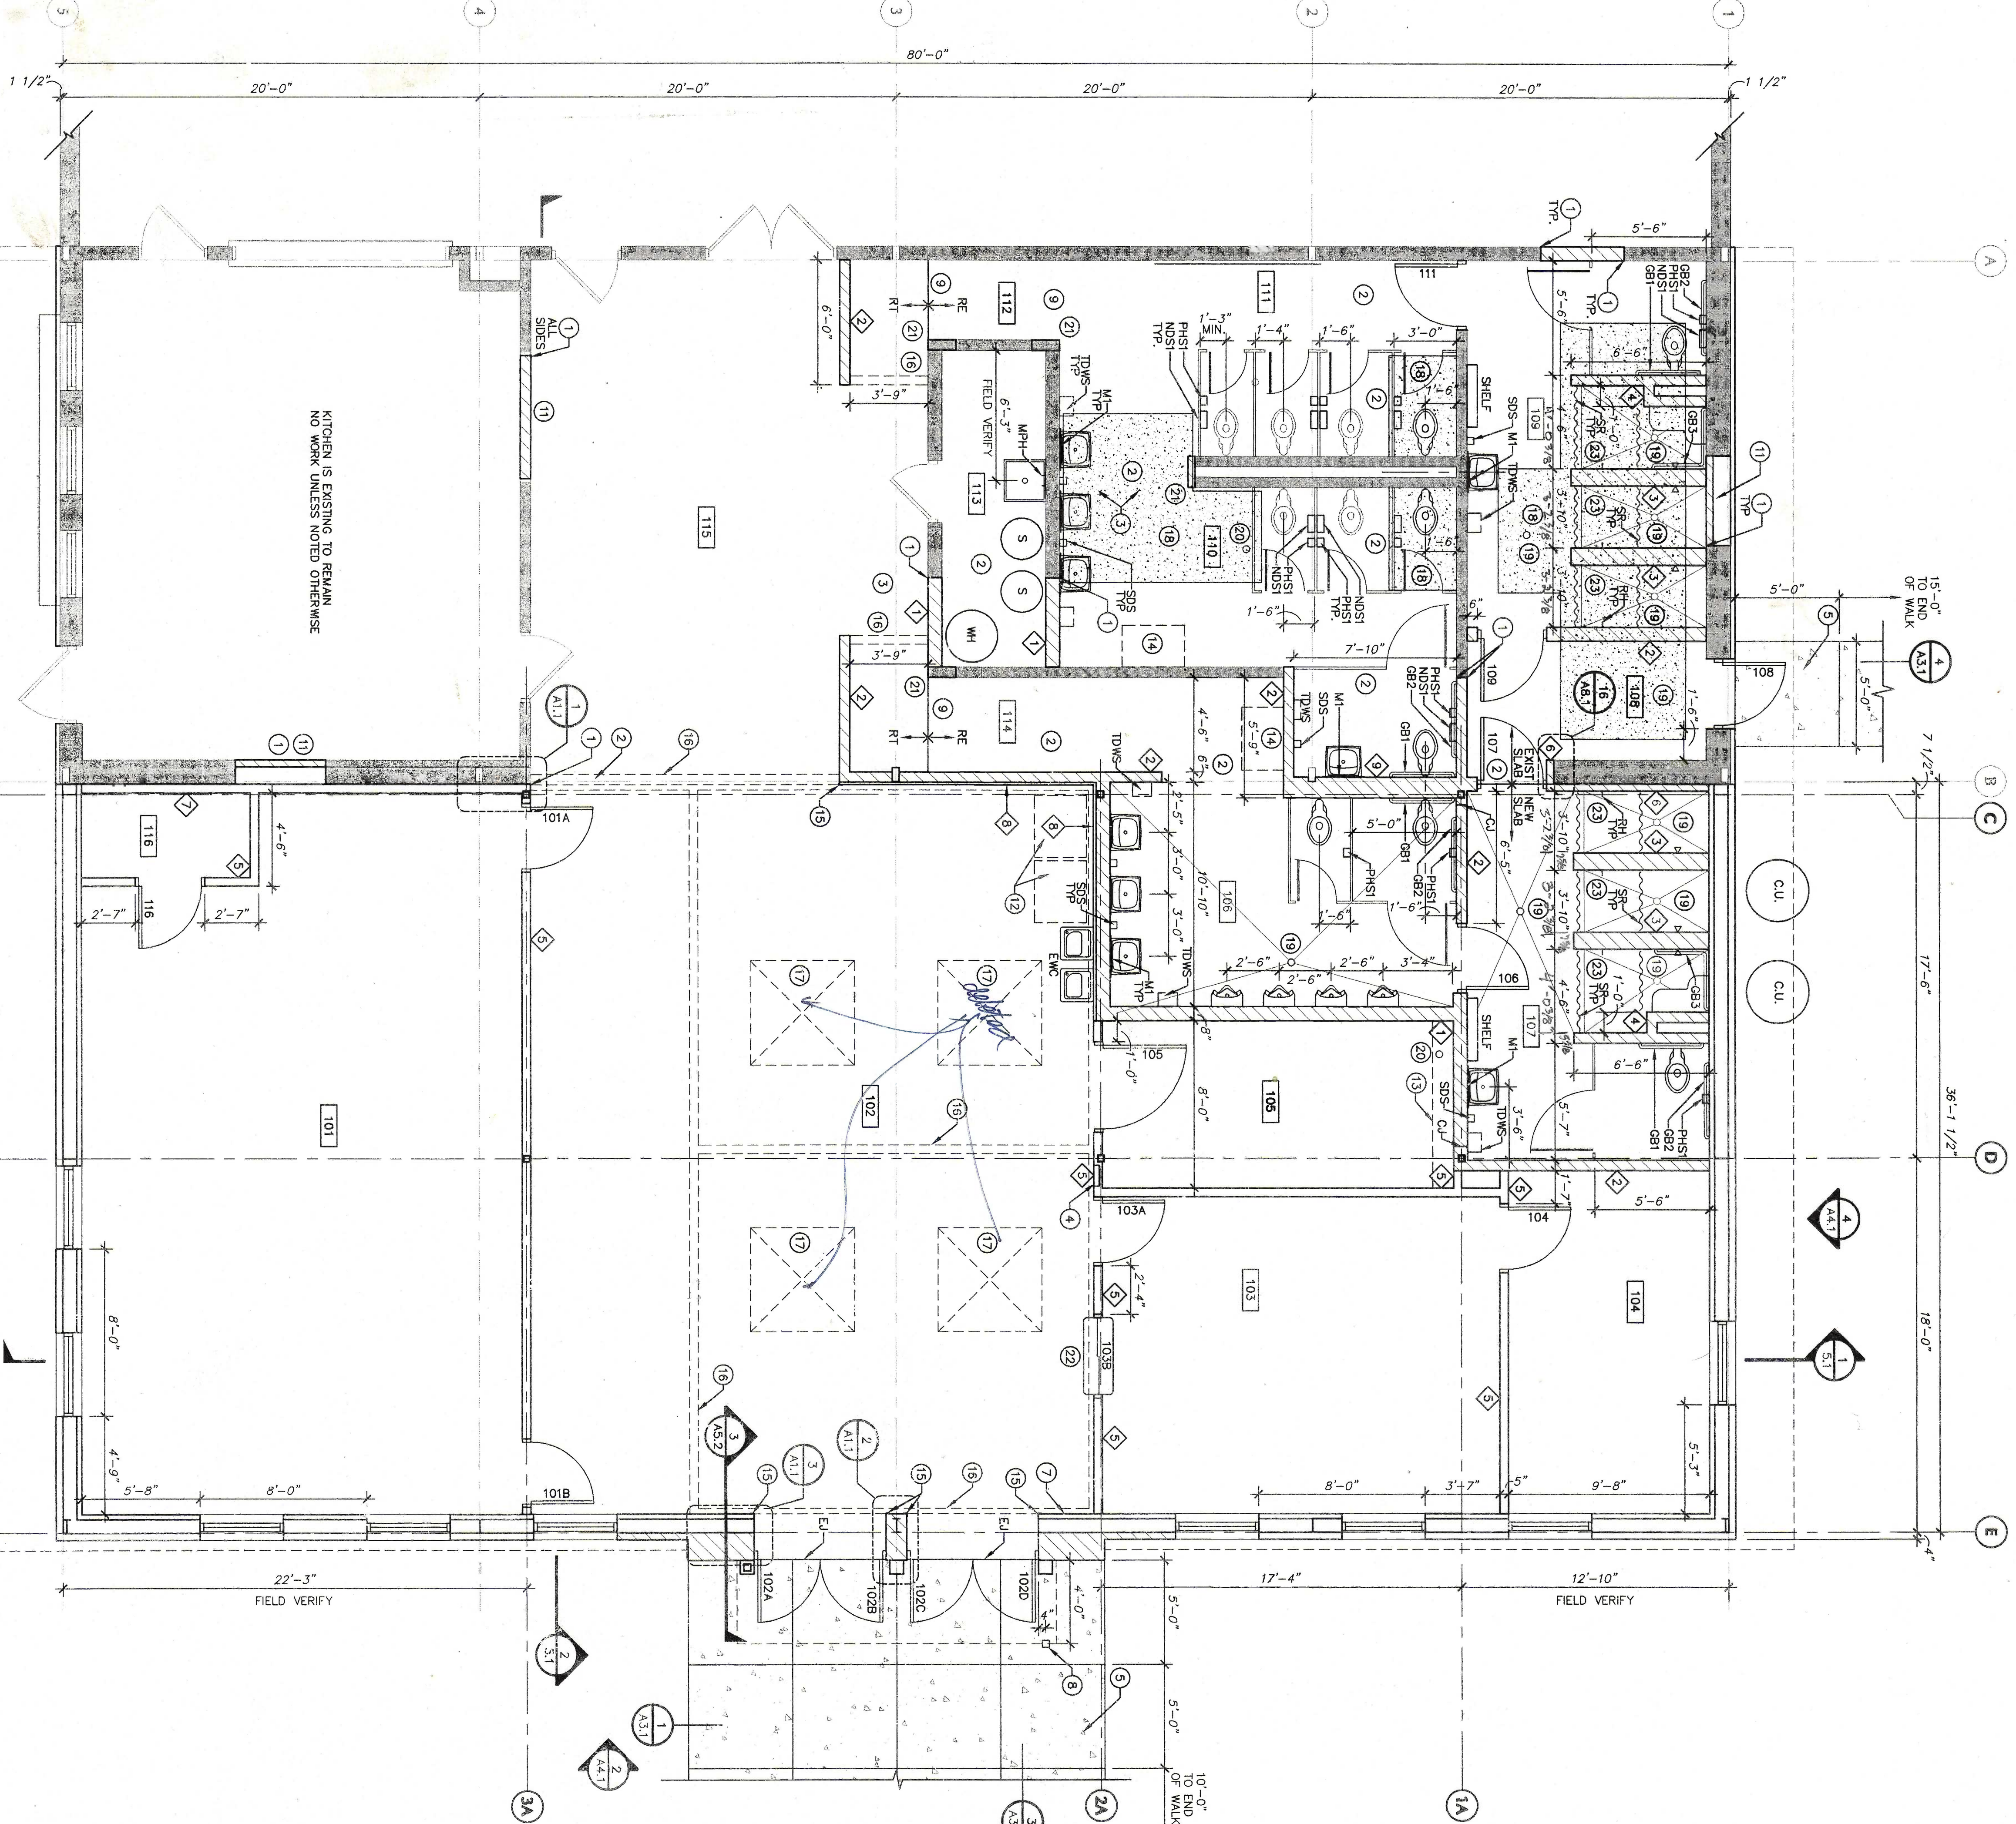
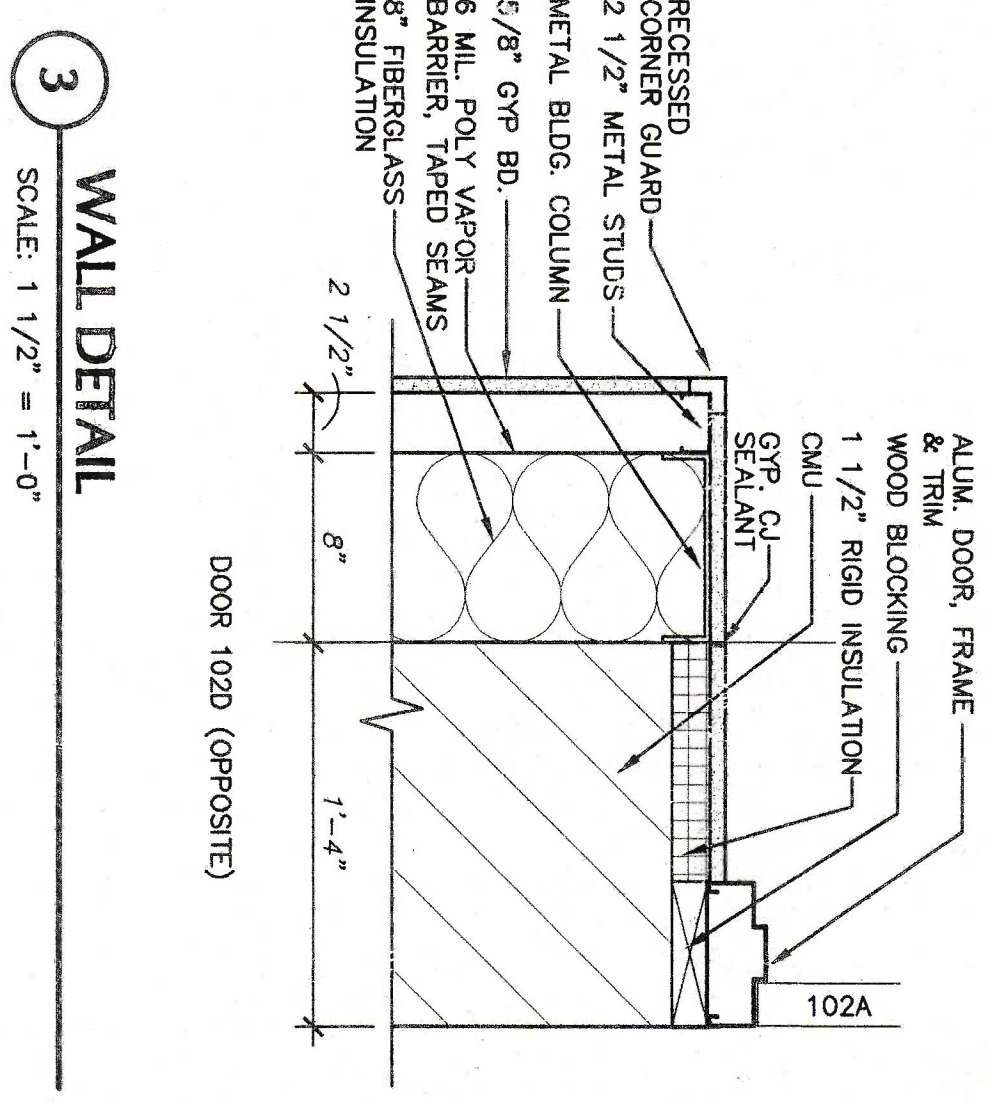
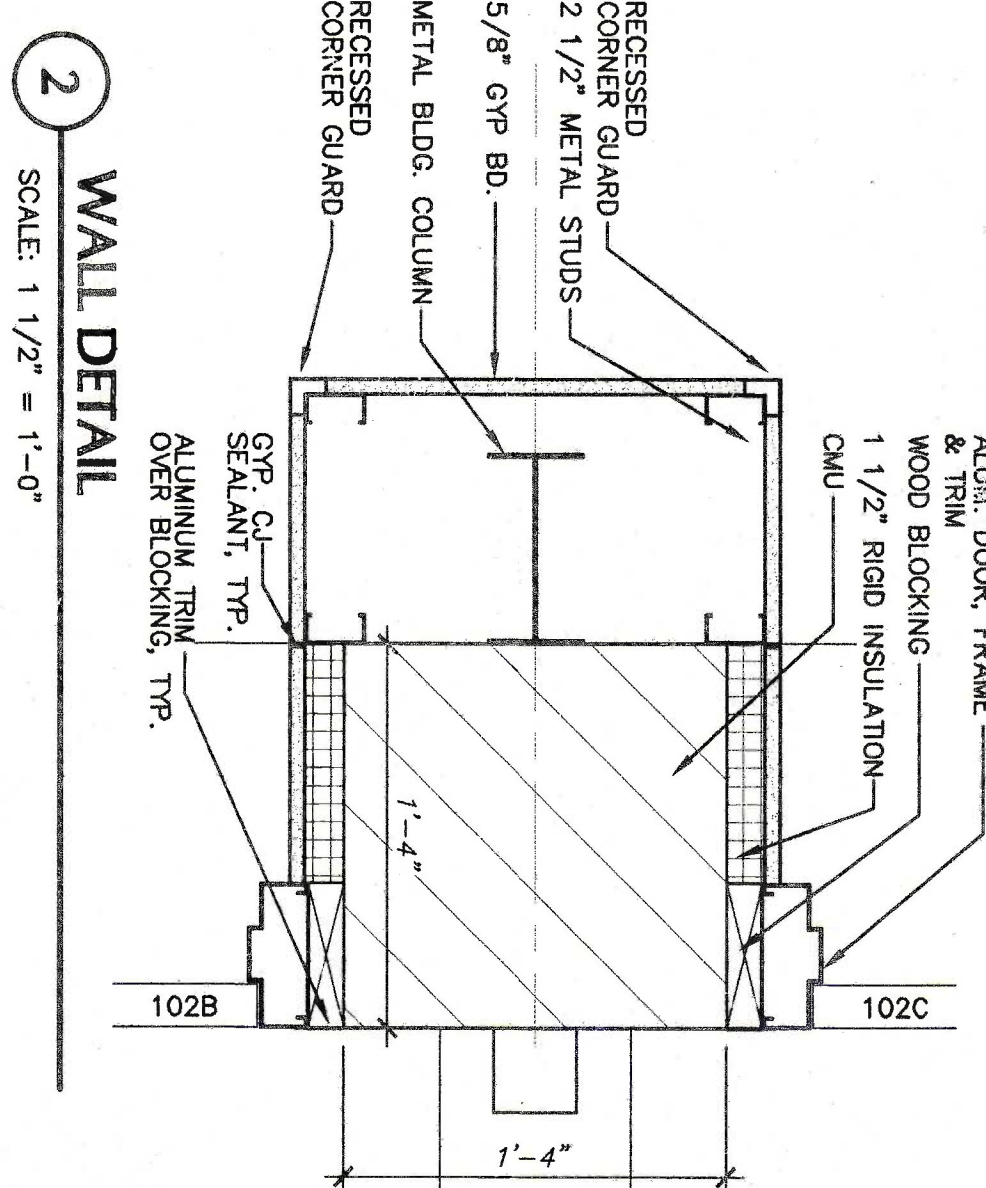


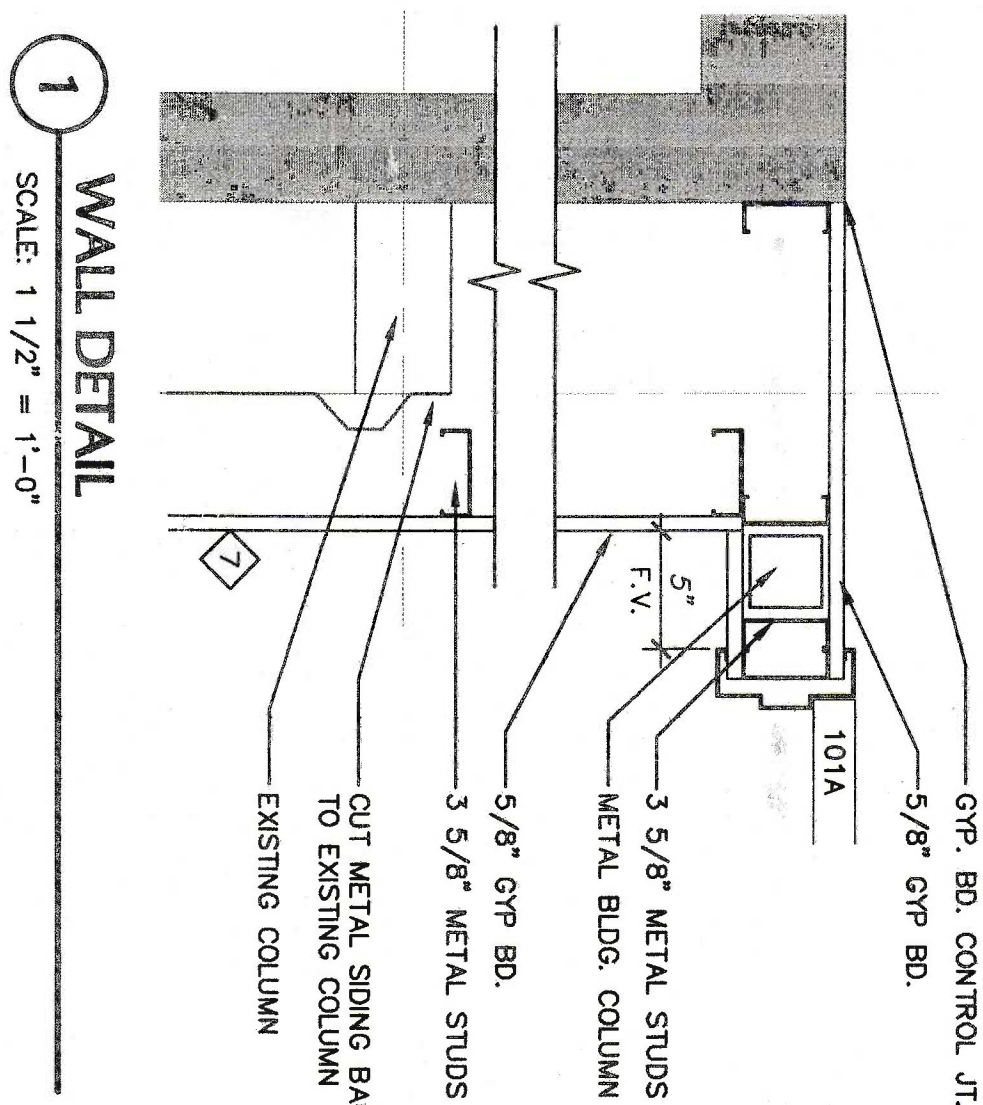

ROOM NUMBERS AND NAMES

101	MEN'S/EXISTS ROOM	109	WOMEN'S SHOWER
102	NEW LOBBY	110	WOMEN'S TOILET ROOM
103	NEW CORRIDOR	111	WOMEN'S TOILET ROOM
104	SUPERVISOR OFFICE	112	CORRIDOR
105	MAINTENANCE OFFICE	113	JANITOR/ELECTRICAL
106	NEW CORRIDOR	114	NEW CORRIDOR
107	MEN'S SHOWER	115	EXISTING LOBBY
108	VESTIBULE	116	WATER METER ROOM

- GENERAL NOTES**
1. SEE SHEET A7.1 FOR PARTITION TYPES.
 2. SEE SHEET A8.1 FOR ROOF FINISH SCHEDULE.
 3. SEE SHEET A8.1 FOR OPENING SCHEDULE.
 4. ALL WALLS ARE DIMENSIONED TO FACE OF WALL UNLESS NOTED OTHERWISE.
 5. ALL EXTERIOR CONCRETE SLABS, PAROONS & WALLS TO BE CONCRETE FINISH S-5.
 6. WALL INLET TO MATCH ADJACENT WALLS IN THICKNESS & FINISH.
 7. SEE SHEET A7.1 FOR TOILET ROOM ACCESSORIES, DETAILS & FINISHES.
 8. ALL NEW EXPOSED CMU CORNERS TO BE BILL-NOSED.

- FLOOR PLAN NOTES**
1. FACE OF NEW WALL FLUSH WITH EXISTING WALL.
 2. PATCH WALLS, FLOORS AND/OR CEILINGS WHERE EXISTING WALLS AND/OR INTERIOR PARTITIONS HAVE BEEN REMOVED. MATCH EXISTING MATERIALS AND FINISHES.
 3. WHERE PLUMBING CONTRADICTION REMOVES EXISTING PLUMBING FIXTURES, PATCH WALLS, FLOORS AND/OR CEILINGS. MATCH EXISTING MATERIALS AND FINISHES.
 4. FIRE EXTINGUISHER CABINET (RECESSED).
 5. 4\"/>
 6. SECTIONS RESPONSIBLE FOR REMOVAL PER AD1.1 SHALL REMOVE EXISTING CONCRETE PATCHES TO BE HIGHER THAN ADJACENT CONCRETE FLOOR. SEE SHEET AD1.1 FOR EXTENT OF DEMOLITION AND PATCHING.
 7. EXISTING WALL PUSH-PLATE SWITCH FOR POWER DOOR OPERATOR. SEE ELECTRICAL.
 8. POST MOUNTED PUSH-PLATE SWITCH FOR POWER DOOR OPERATOR.
 9. PATCH WALLS WHERE EXISTING DOOR FRAME HAS BEEN REMOVED.
 10. INLET EXISTING OPENING WITH CMU MATCH EXISTING WALL THICKNESS EXISTING MATERIALS & FINISHES.
 11. JENKING MACHINES BY OWNER.
 12. STORAGE SHELVING - O.F.O.L.
 13. BABY CHANGING STATION - O.F.O.L.
 14. CORNER GUARD FROM BASE TO 7'-8\"/>
 15. GYP. BOARD AT CEILING.
 16. 5'x5\"/>
 17. NEW CONC FLOOR, 4\"/>
 18. NEW CONC FLOOR, 4\"/>
 19. NEW FLOOR DRAIN - 1 1/2\"/>
 20. NEW FLOOR DRAIN - 1\"/>
 21. NEW CMU CORNER W/BULL NOSE UP TO 9'-4\"/>
 22. WHERE WALL WAS CUT OUT.
 23. FOLD DOWN SHOWER BENCH, SEE SPECIFICATION



ARCHITECT:
 STRUCTURAL ENGINEER:
 MECHANICAL ENGINEER:
 ELECTRICAL ENGINEER:
 PLUMBING ENGINEER:
 Durrant

REVISIONS

PROJECT NO. 01170-00

DATE	3/5/01
DRAWN BY	JUN
CHECKED BY	PWG
SHEET CONTENTS	NEW CONSTRUCTION PLAN